

ID	ALG	STA	OFFSET	LT/RT	NORTHING	EASTING	SHEET S-2.2		
							A	B	C
FM-MC1-1	MC1	342+73.05	0	Rt	846226.37	622539.15	5'	2.71	6.46
FM-MC2-1	MC2	231+32.02	0	Rt	849243.99	612440.08	7'	1.96	6.71
FM-MC21N-1	MC2-1N	500+28.00	0	Rt	849119.29	611133.91	6'	1.14	5.39
FM-MC21N-2	MC2-1N	537+97.00	0	Rt	851483.40	609740.18	4'	2.99	6.24
FM-MC21S-1	MC2-1S	400+92.39	0	Rt	849027.06	611161.46	5'	2.28	6.03
FM-MC22N-1	MC2-2N	800+43.48	0	Rt	849287.70	612491.42	7'	1.11	5.86
FM-MC22N-2	MC2-2N	826+00.70	0	Rt	851782.75	612429.42	5'	2.9	6.65
FM-MC3-3	MC3	665+98.08	0	Rt	854506.52	608895.77	4'	2.95	6.2
FM-MC31N-3	MC3-1N	714+33.05	0	Rt	855807.62	611152.20	4'	2.46	5.71
FM-MC31N-4	MC3-1N	715+44.00	0	Rt	855918.57	611151.42	4'	1.74	4.99
FM-MC32N-1	MC3-2N	900+30.00	0	Rt	855787.54	611122.33	5'	2.35	6.1
FM-MC32N-2	MC3-2N	914+55.14	0	Rt	855824.84	609774.92	3'	2.13	4.88
FM-MC33N-1	MC3-3N	0+45.00	0	Rt	854550.72	608921.92	4'	2.92	6.17
TOFM-MC1-1	MC-1	309+83.49	45	Lt	843975.26	621023.43	5'	5.21	8.96
TOFM-MC1-2	MC-1	315+70.73	45	Lt	843974.46	621533.43	6'	9.87	14.12
TOFM-MC1-3	MC-1	342+32.063	45	Lt	846165.96	622531.37	6'	2.63	6.88
TOFM-MC2-1	MC-2	179+31.23	45	Lt	849273.51	617520.90	3'	6.08	8.83
TOFM-MC2-2	MC-2	196+71.25	35	Lt	849276.93	615900.91	4'	4.4	7.65
TOFM-MC2-3	MC-2	206+41.27	35	Lt	849279.06	614930.89	4'	5.29	8.54
TOFM-MC2-4	MC-2	219+41.27	35	Lt	849281.84	613630.90	4'	2.66	5.91
TOFM-MC2-5	MC-2	233+66.38	35	Lt	849087.90	612326.63	3'	2.63	5.38
TOFM-MC21N-1	MC-2-1N	536+90.74	35	Rt	851448.53	609787.27	3'	3.18	5.93
TOFM-MC21S-2	MC-2-1S	400+50.00	35	Rt	849069.63	611126.66	3'	0.1	2.85
TOFM-MC21S-3	MC-2-1S	400+40.00	NA	NA	849229.49	611154.45	3'	1.84	4.59
TOFM-MC22N-1	MC-2-2N	825+73.15	106	Rt	851888.75	612456.43	4'	1.43	4.68
TOFM-MC22N-2	MC-2-2N	0+00.00	0	Rt	851888.75	612526.43	4'	0.66	3.91
TOFM-MC22N-3	MC-2-2N	824+85.00	35	Lt	851729.21	612456.44	4'	2.63	5.88
TOFM-MC3-1	MC-3	604+00.00	35	Lt	854360.15	614947.53	3'	3.03	5.78
TOFM-MC3-2	MC-3	654+12.02	59	Lt	854320.25	609951.96	3'	3.92	6.67
TOFM-MC3-3	MC-3	655+66.24	35	Rt	854543.79	609927.53	3'	4.05	6.8
TOFM-MC3-4	MC-3	656+72.20	35	Rt	854543.54	609821.57	3'	2.84	5.59
TOFM-MC3-5	MC-3	674+35.90	35	Lt	854073.15	608454.02	3'	1.92	4.67
TOFM-MC3-6	MC-3	690+20.14	35	Lt	854347.48	607165.20	3'	2.06	4.81
TOFM-MC3-7	MC-3	690+20.14	35	Rt	854382.46	607130.18	3'	2.32	5.07
TOFM-MC31N-1	MC3-1N	707+00.00	35	Lt	855074.89	611109.89	3'	2.79	5.54
TOFM-MC31N-2	MC3-1N	715+00.03	35	Lt	855874.35	611116.73	3'	1.99	4.74
TOFM-MC32N-1	MC3-2N	913+24.34	59	Lt	855900.07	609892.09	3'	-0.22	2.53
TOFM-WSIF-1	WS-IF	127+91.27	35	Rt	844022.45	617524.15	3'	1.3	4.05
TOFM-WSIE-2	WS-IF	1015+25.00	35	Rt	845261.55	620206.35	3'	3.48	6.23
TOFM-WSIE-3	WS-IE	1028+00.00	35	Rt	846536.53	620212.96	3'	3.57	6.32
TOFM-WSIE-4	WS-IE	1041+50.00	35	Rt	847886.51	620219.94	3'	3.69	6.44
TOFM-WSIE-5	WS-IE	1056+45.96	35	Rt	849241.29	619898.43	3'	3.82	6.57
TOFM-WSIE-6	WS-IE	1093+35.00	35	Rt	852018.17	617497.67	3'	3.4	6.15
TOFM-WSIE-7	WS-IE	1121+86.52	35	Rt	854187.42	615646.54	3'	3.32	6.07
TOFM-WSIE-8	WS-IE	1130+97.05	35	Rt	854787.86	615123.88	3'	4.18	6.93
TOFM-WSIE-9	WS-IE	1153+97.05	35	Rt	856522.83	613625.51	3'	3.95	6.7
TOFM-WSIE-10	WS-IE	1171+97.05	35	Rt	857884.78	612448.61	3'	4.89	7.64
TOFM-WSIE-11	WS-IE	1194+19.09	35	Rt	859547.46	611018.56	3'	6.01	8.76
TOFM-WSIE-12	WS-IE	1206+47.05	35	Rt	859643.70	609798.93	3'	5.21	7.96
TOFM-WSIE-13	WS-IE	1219+47.05	35	Rt	859637.86	608498.36	3'	3.6	6.35
TOFM-WSIF-2	WS-IF	140+11.27	35	Rt	845242.45	617526.06	3'	1.48	4.23
TOFM-WSIF-3	WS-IF	146+41.27	35	Rt	845872.45	617526.95	3'	3.17	5.92
TOFM-WSIF-4	WS-IF	159+41.27	35	Rt	847172.35	617527.08	3'	3.87	6.62
TOFM-WSIF-5	WS-IF	165+86.27	35	Rt	847817.35	617526.29	3'	5.58	8.33
TOFM-WSIF-6	WS-IF	175+91.27	35	Rt	848822.51	617529.73	3'	5.67	8.42

Job No. 647979
Designed MFM
Drawn JD
Checked JZ
Reviewed JZ
Approved JZ
Reg. No. 25118
Plot Date 12-18-14

60% SUBMITTAL
NOT FOR
CONSTRUCTION

PREPARED BY:
PARSONS
222 SOUTH MILL AVENUE
SUITE #220
TEMPE, ARIZONA 85281
(602)952-9195
(602)952-9303 fax


**PIMA MARICOPA
IRRIGATION
PROJECT**
P.O. BOX C
ROUTE A STREET
SACATON, AZ 85147
(520)562-6700
(520)562-6791 FAX

REACHES WS-1E AND WS-1F

FLOW METER IN MANHOLE TABLE SHEET
SHEET 2 OF 2


DRAWING NAME
S-2.3


Rev

Date


Description

By

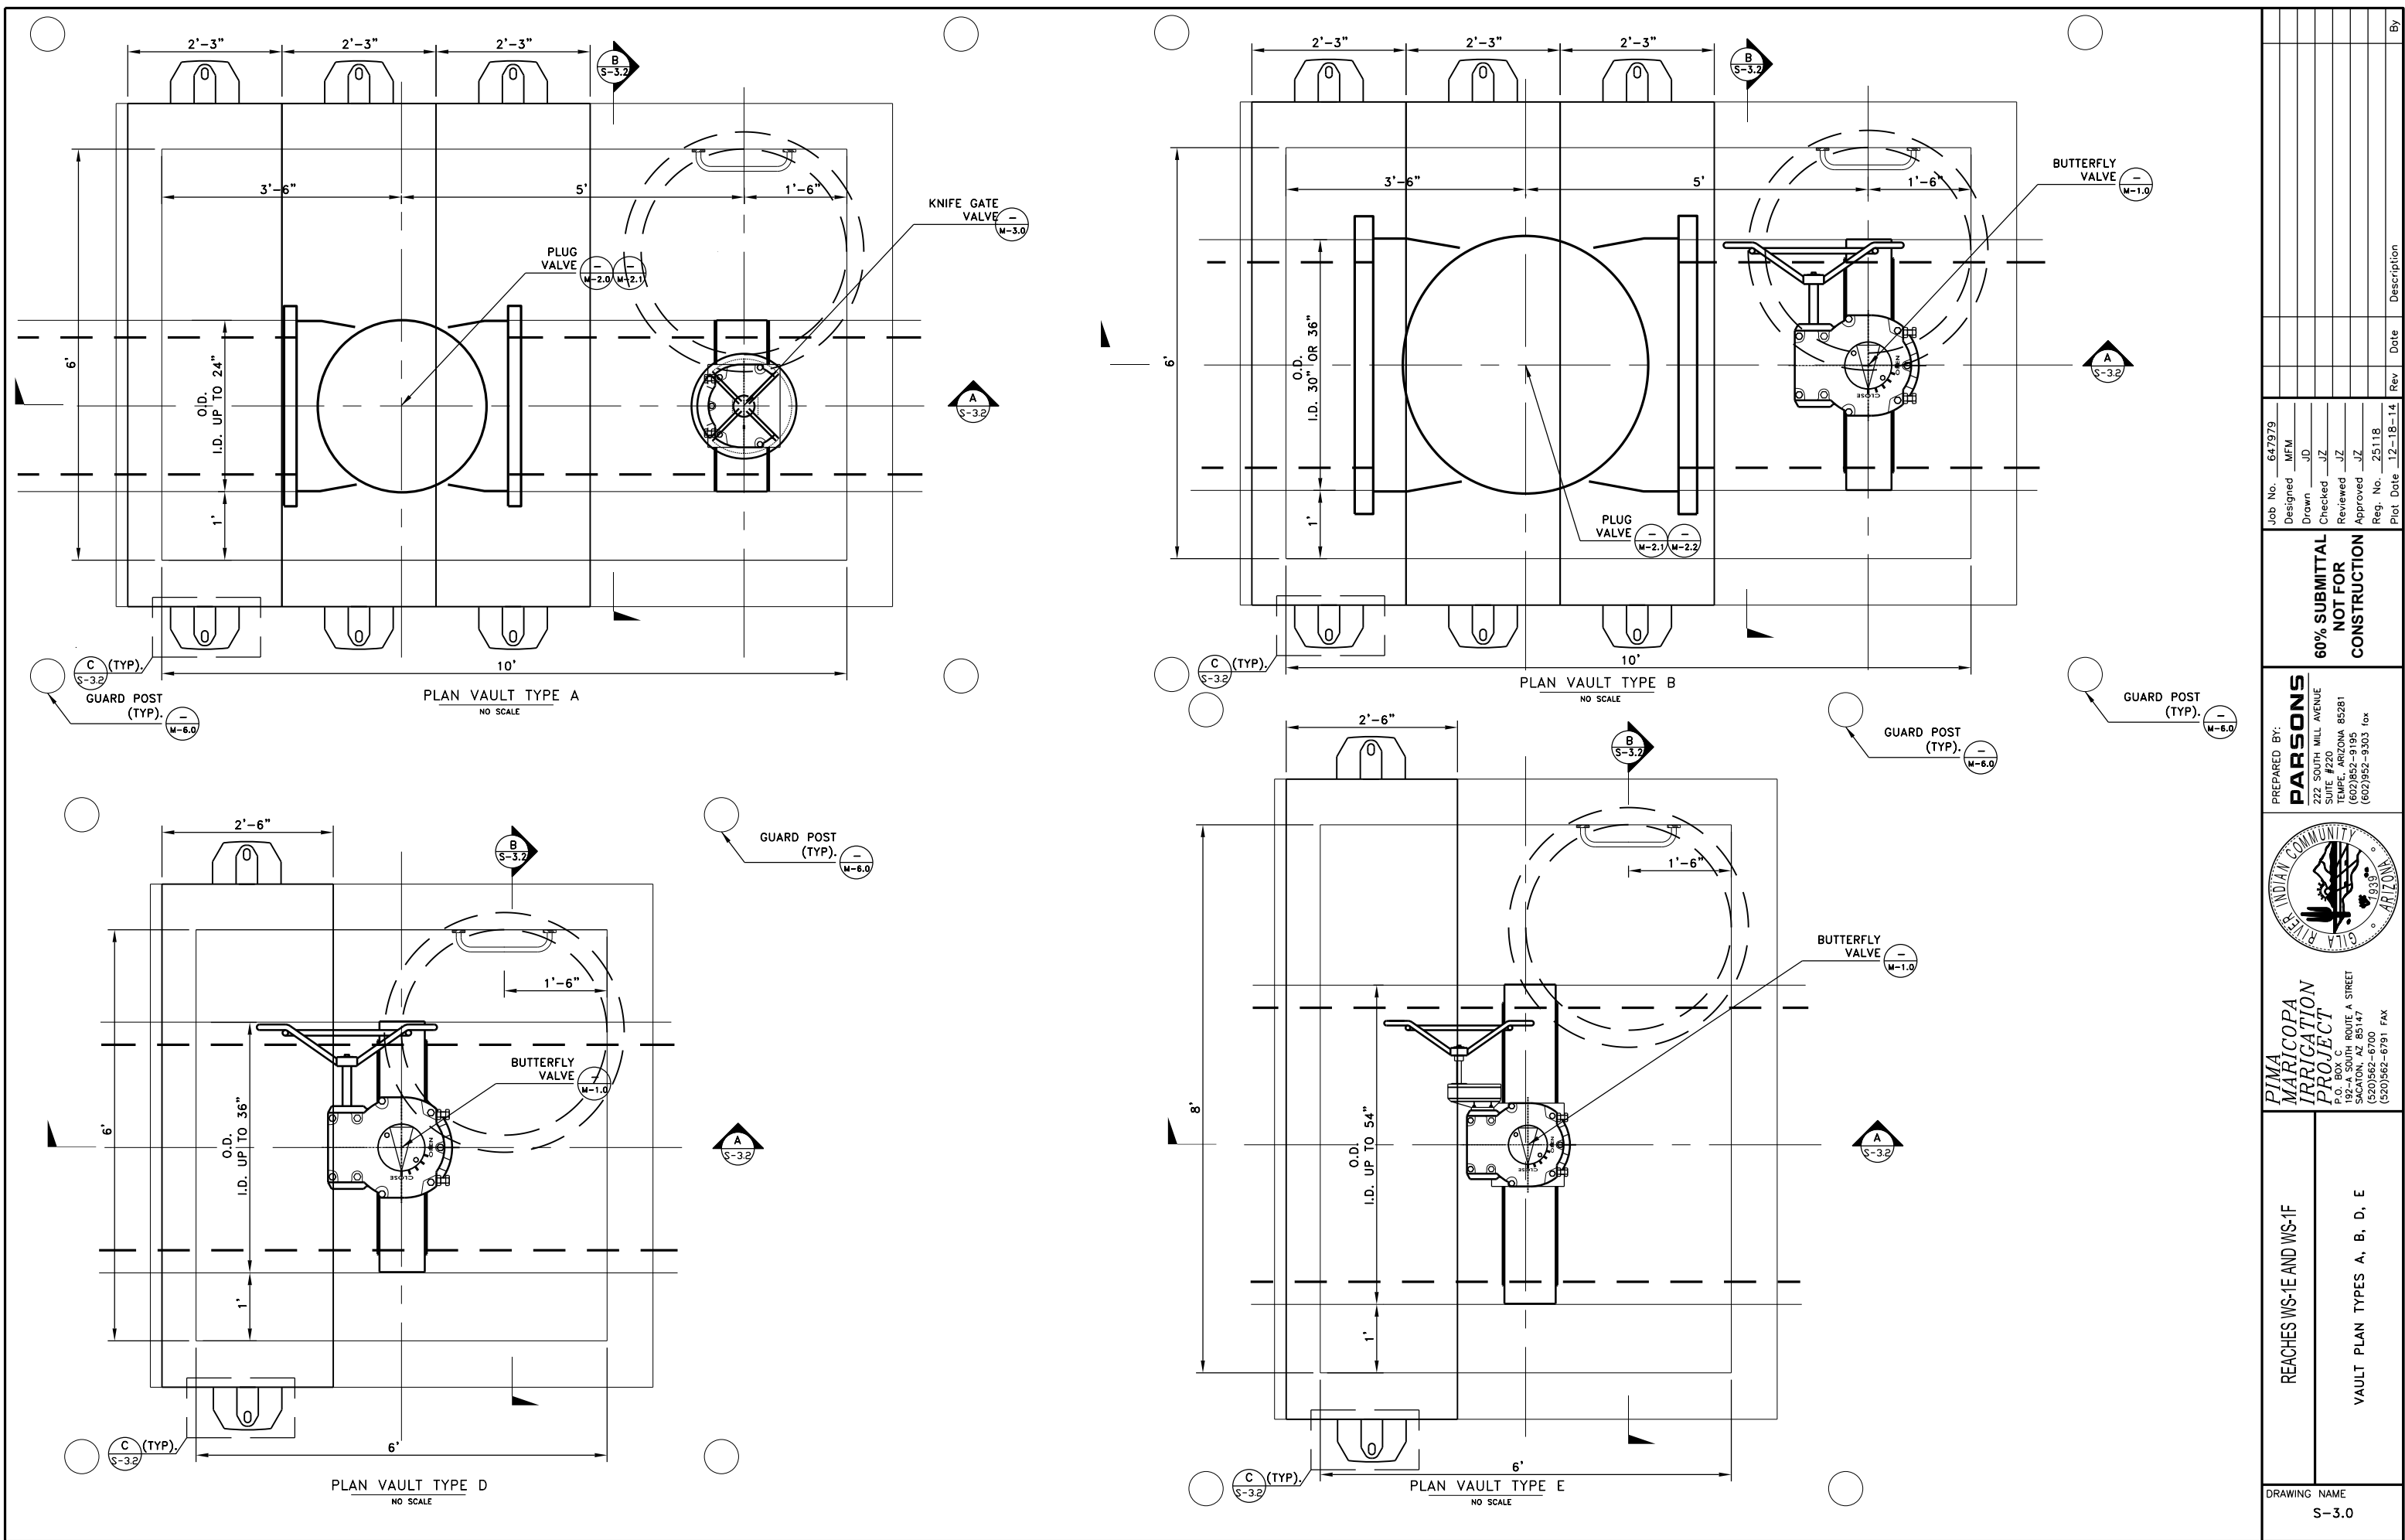

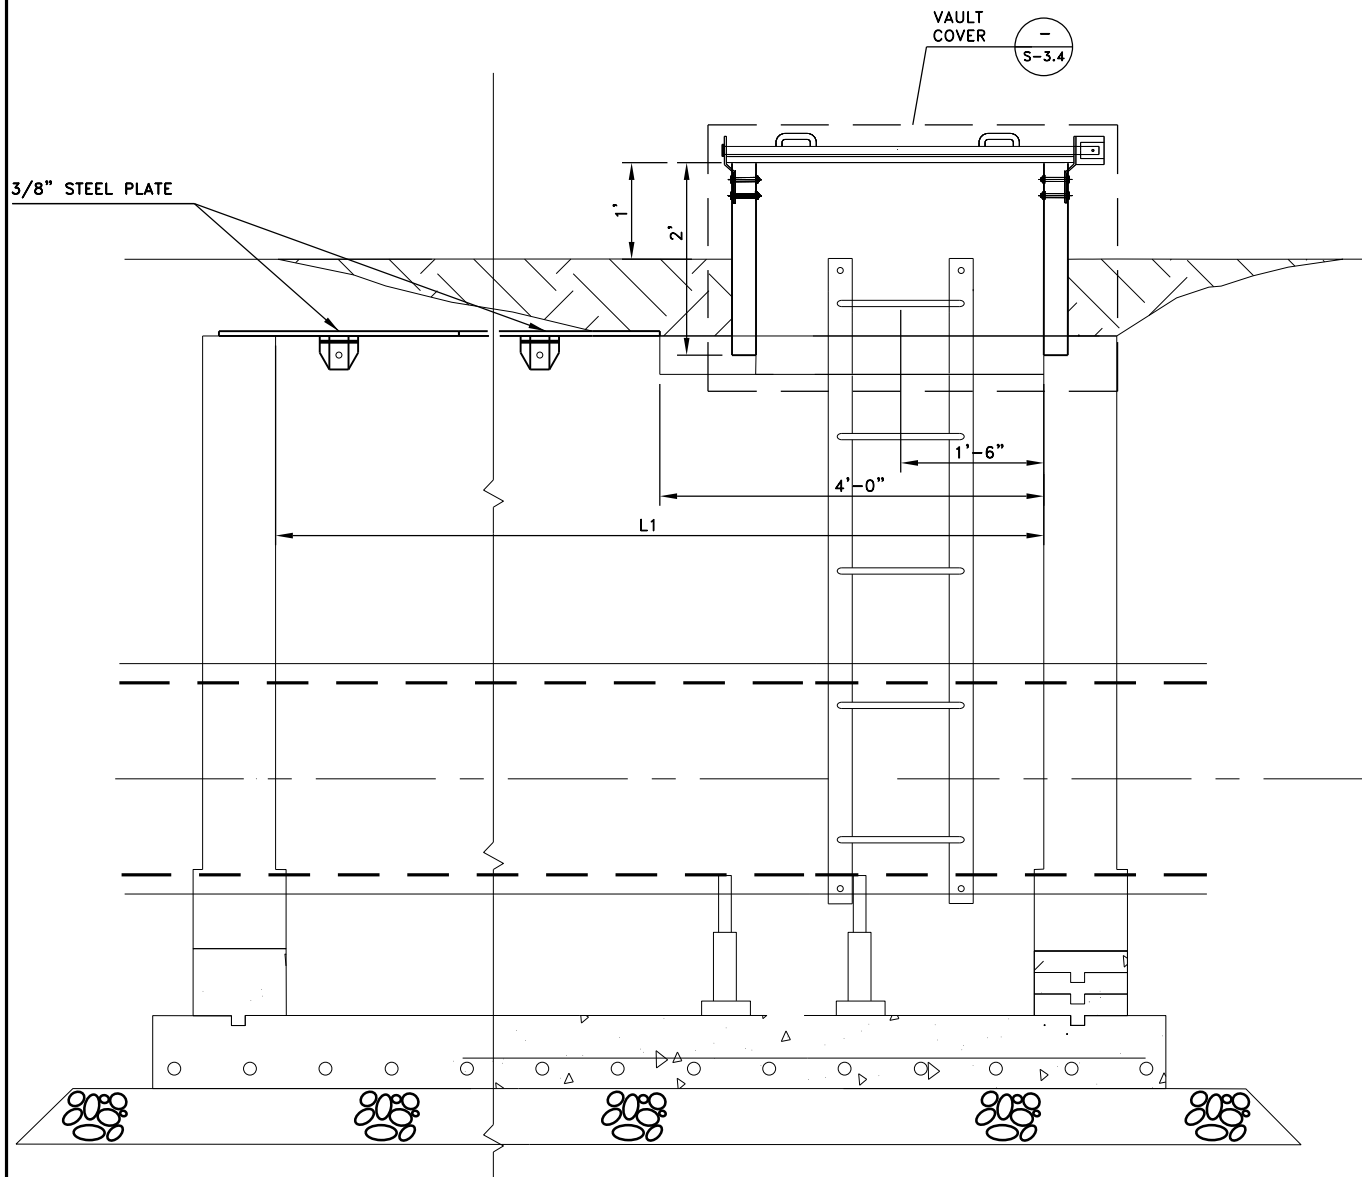


A
-
VAULT SECTION
NO SCALE

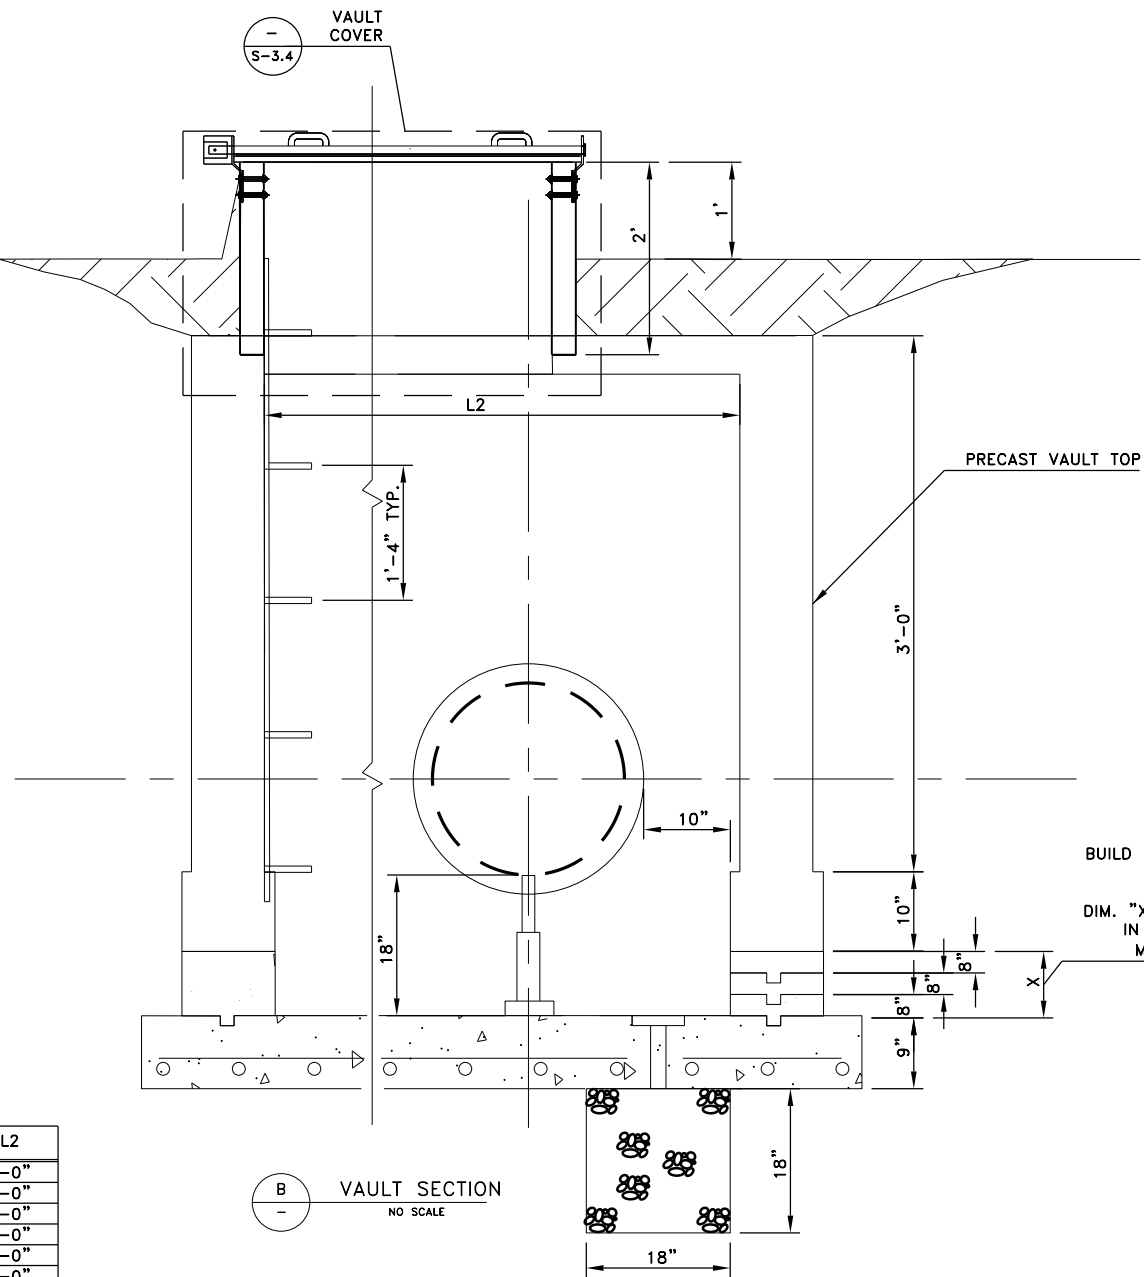


B
-
VAULT SECTION
NO SCALE


VAULT	L1	L2
TYPE A	10'-0"	6'-0"
TYPE B	10'-0"	6'-0"
TYPE C	14'-0"	8'-0"
TYPE D	6'-0"	6'-0"
TYPE E	6'-0"	8'-0"
TYPE F	6'-0"	6'-0"

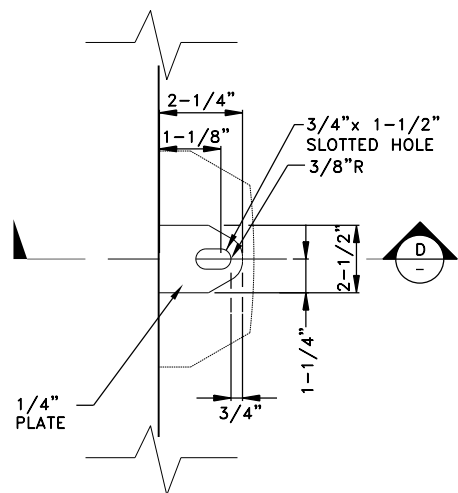

C
-
COVER LATCH PLATE DETAIL
NOT TO SCALE

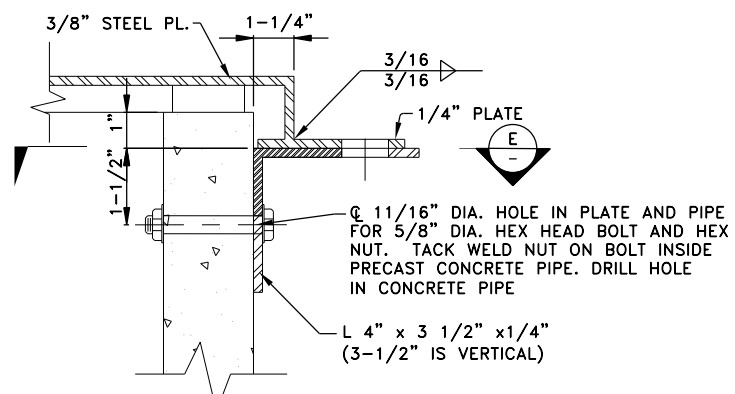


D
-
SECTION
NOT TO SCALE

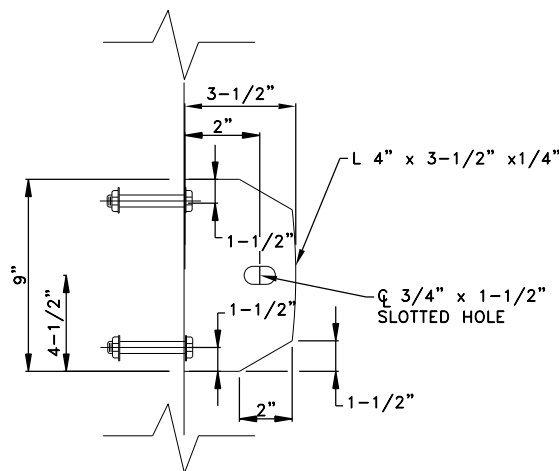


E
-
BASE LATCH PLATE DETAIL
NOT TO SCALE

Job No.	647979	Designed	MFM	Drawn	JU	Checked	JZ	Reviewed	JZ	Approved	JZ	Reg. No.	25118	Plot Date	12-18-14	Rev	Date	Description	By
60% SUBMITTAL NOT FOR CONSTRUCTION																			
PREPARED BY: PARSONS 222 SOUTH MILL AVENUE SUITE #220 TEMPE, ARIZONA 85281 (602)952-9195 (602)952-9303 fax																			
PIMA MARICOPA IRRIGATION PROJECT P.O. BOX C, ROUTE A STREET SACATON, AZ 85147 (520)562-6700 (520)562-6791 FAX																			
REACHES WS-1E AND WS-1F																			
VAULT SECTIONS																			
DRAWING NAME S-3.2																			

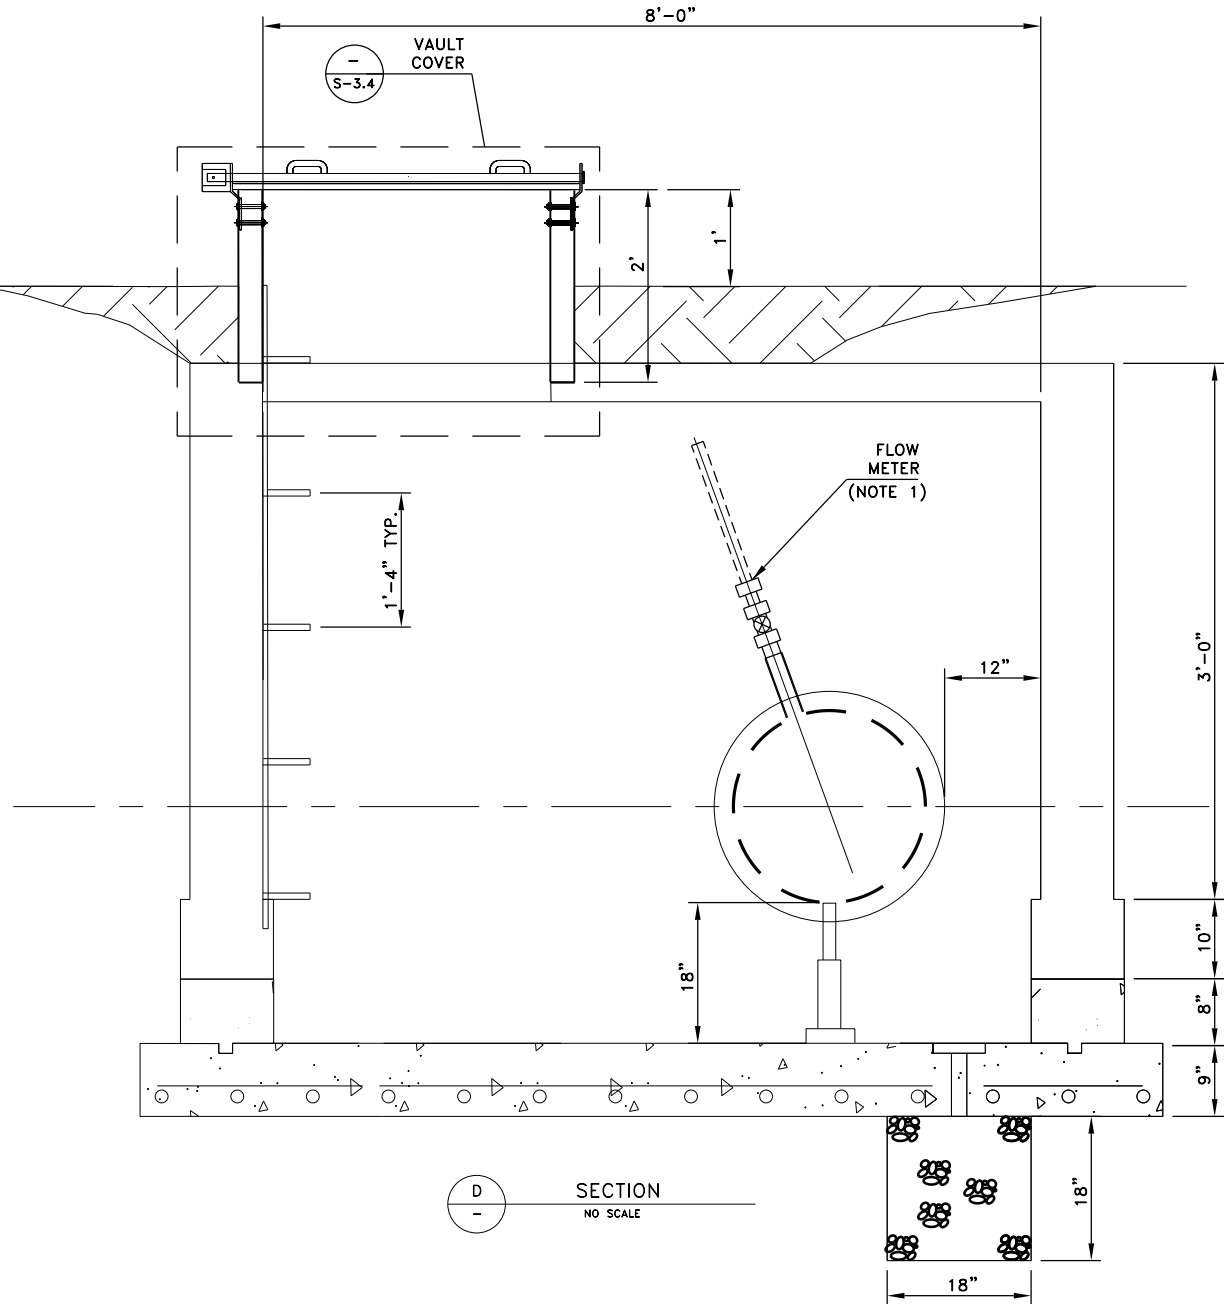

DRAWING NAME	S-3.3
--------------	-------


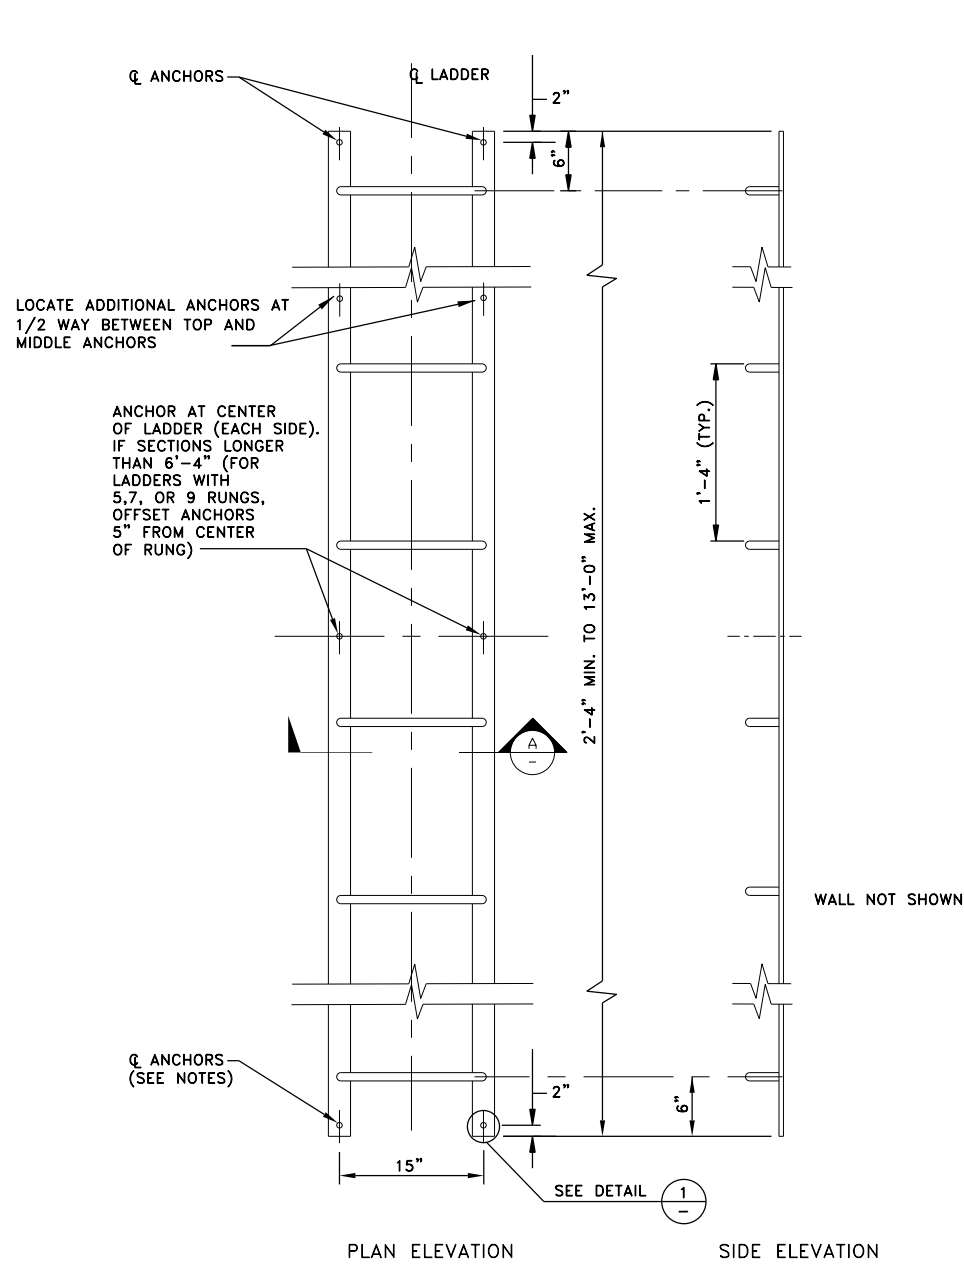


LADDER ELEVATION DETAILS





SCALE: 1-1/2" = 1'-0"

NOTES:

- LADDERS SHALL BE FABRICATED FROM ASTM A36 STEEL.
- 3/8" DIAM. SS ANCHORS WITH SIMPSON STRONG TIE SET ADHESIVE (ICBO ER-5279) OR EQUAL AS APPROVED BY ENGINEER. DRILL HOLE MIN. 2-1/4". DO NOT USE HAMMER TO SET HOLE.
- LADDERS SHALL BE PAINTED WITH TRAFFIC YELLOW PAINT PER SPECIFICATIONS.

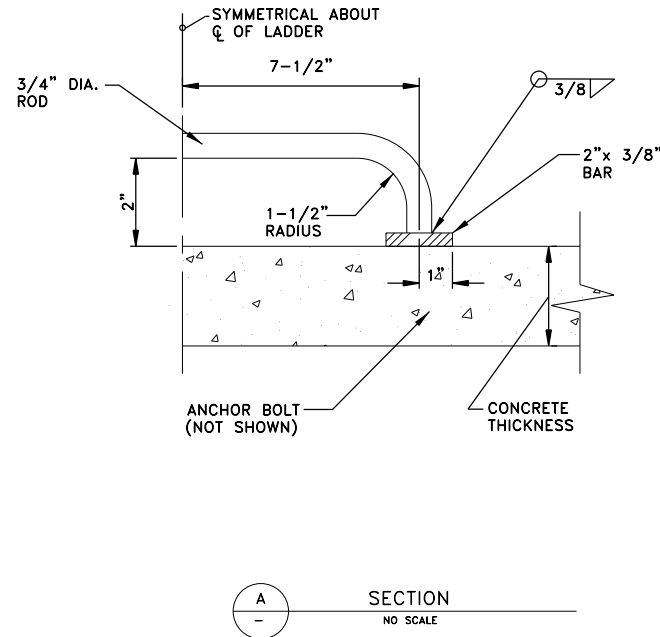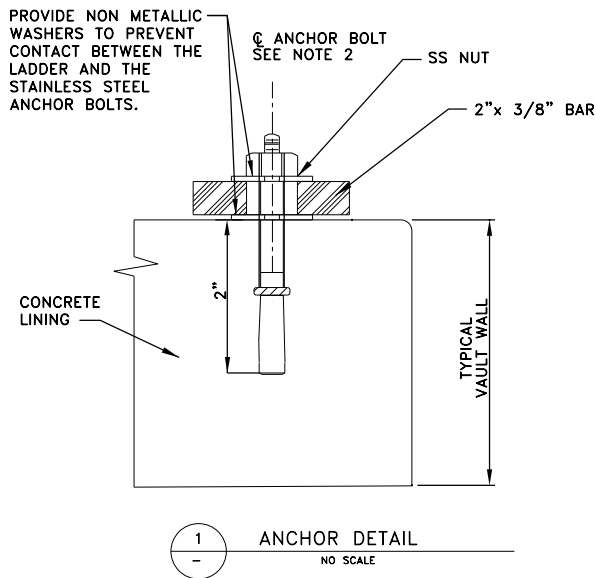

DRAWING NAME		By
REACHES WS-1E AND WS-1F		
VAULT DETAILS - LADDER		
S-3.5		
Job No. 647979		Rev
Designed MFM		Date
Drawn JD		
Checked JZ		
Reviewed JZ		
Approved JZ		
Reg. No. 25118		
Plot Date 12-18-14		Description
60% SUBMITTAL		
NOT FOR		
CONSTRUCTION		
PREPARED BY:		
PARSONS		
222 SOUTH MILL AVENUE		
SUITE #220		
TEMPE, ARIZONA 85281		
(602)952-9195		
(602)952-9303 fax		
PIMA MARICOPA IRRIGATION PROJECT		
P.O. BOX C, ROUTE A STREET		
SACATON, AZ 85147		
(520)562-6700		
(520)562-6791 FAX		
GILA RIVER INDIAN COMMUNITY		
ARIZONA		

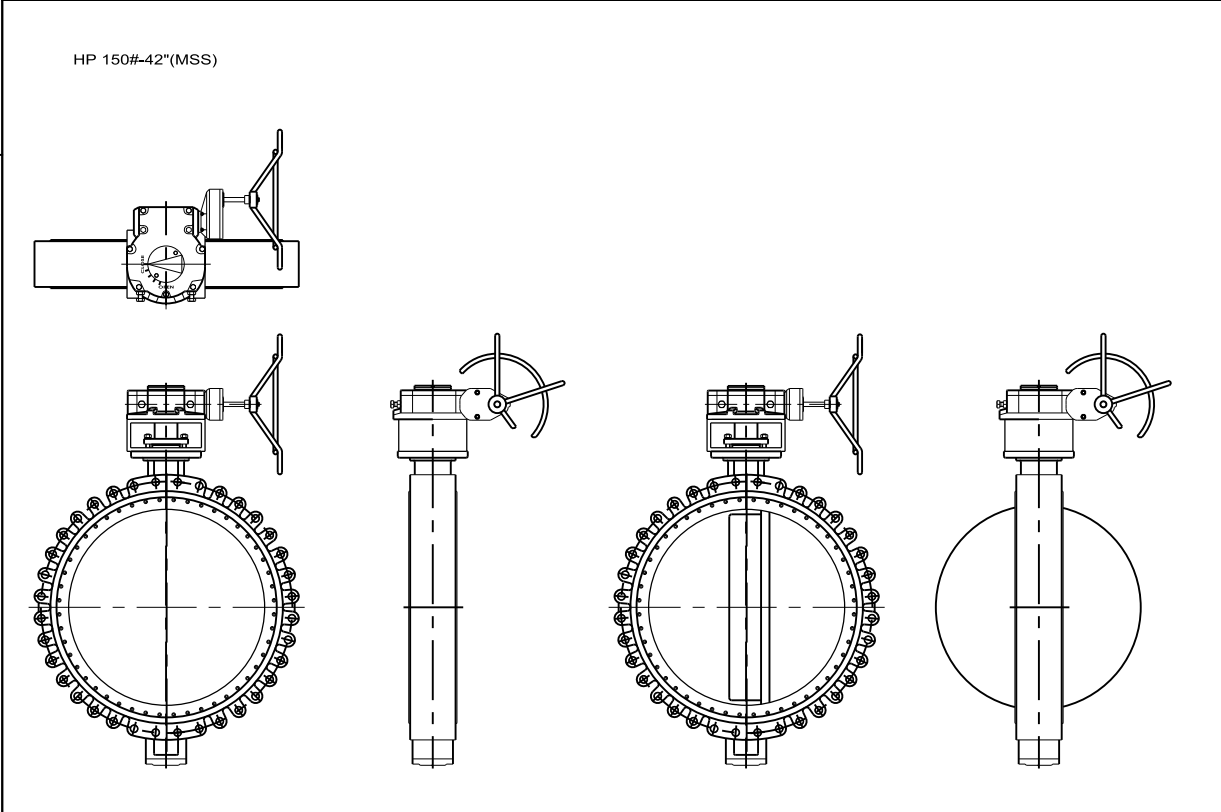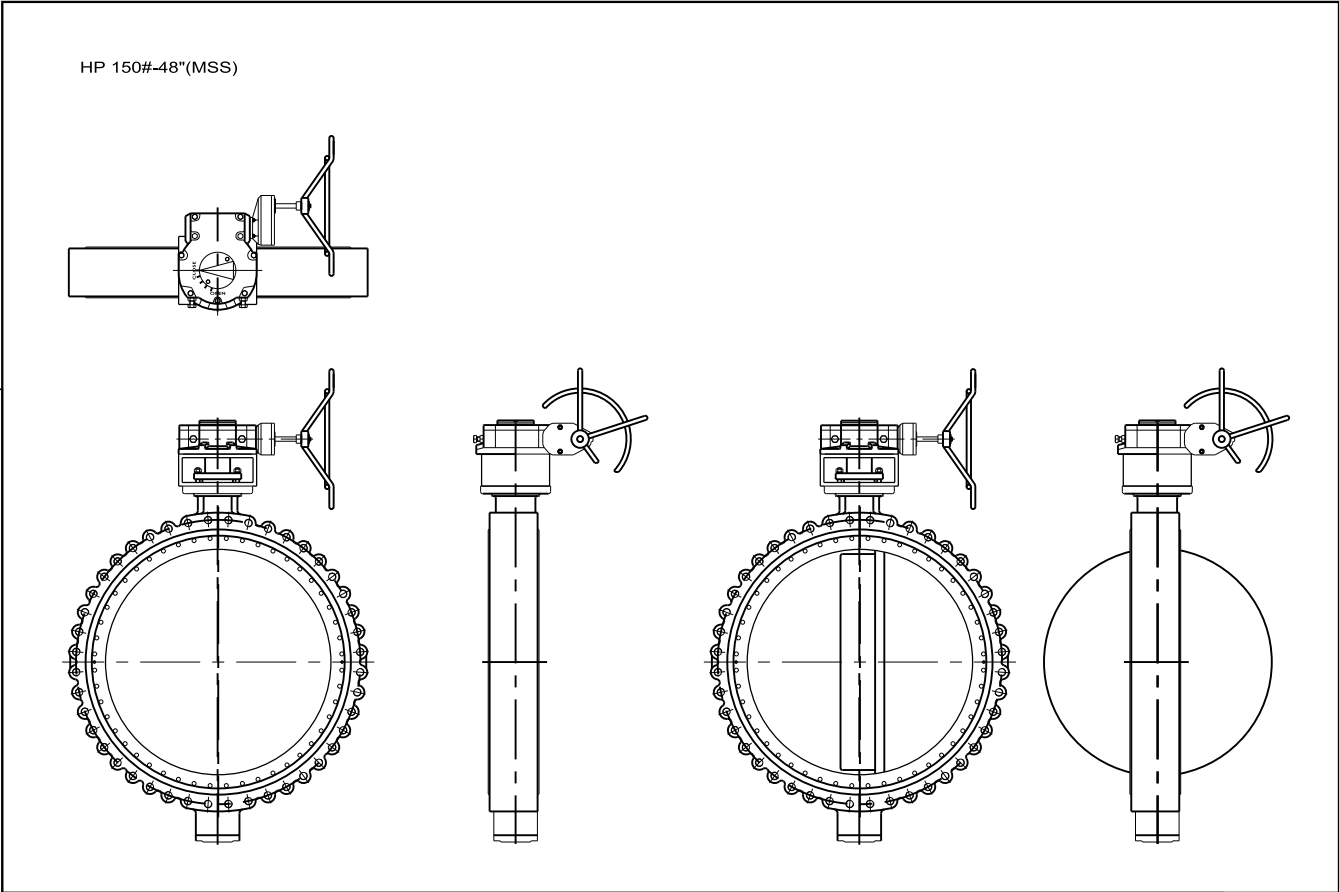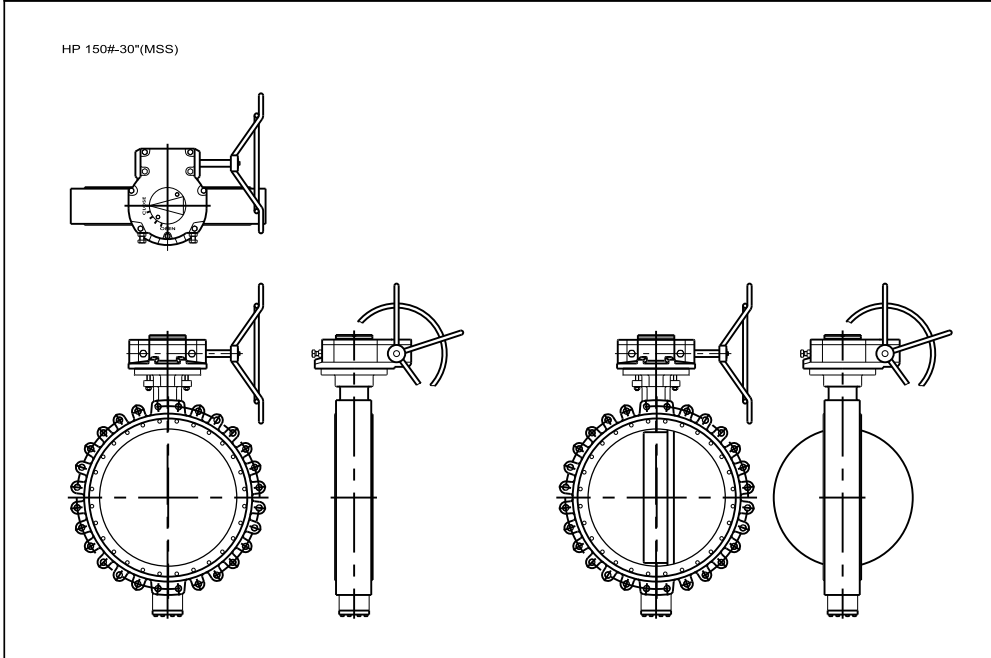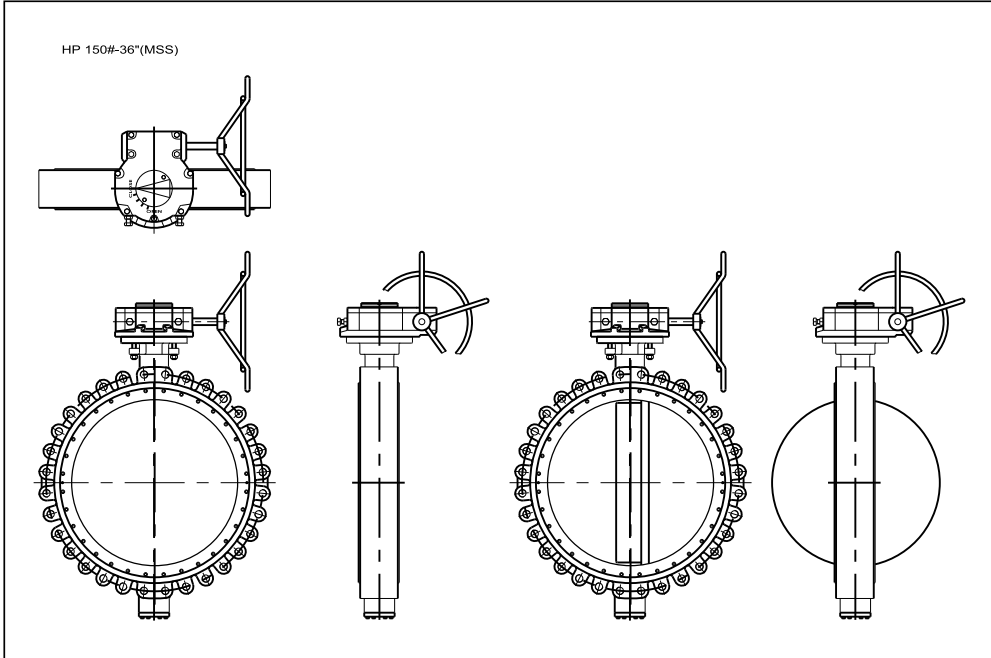


NOTES:

1. MANUFACTURER'S DATA SHEET
TO BE PROVIDED AT 90%.

DRAWING NAME M-1.0		REACHES WS-1E AND WS-1F BUTTERFLY VALVE		PIMA MARICOPA IRRIGATION PROJECT P.O. BOX C, ROUTE A STREET SACATON, AZ 85147 (520)562-6700 (520)562-6791 FAX  PREPARED BY: PARSONS 222 SOUTH MILL AVENUE SUITE #220 TEMPE, ARIZONA 85281 (602)952-9195 (602)952-9303 fax		60% SUBMITTAL NOT FOR CONSTRUCTION		Job No. 647979 Designed MFM Drawn JD Checked JZ Reviewed JZ Approved JZ Reg. No. 25118 Plot Date 12-18-14		Rev	Date	Description	By
-----------------------	--	--	--	--	--	---	--	--	--	-----	------	-------------	----

NOTES:
1. MANUFACTURER'S DATA SHEET (HENRY PRATT COMPANY)

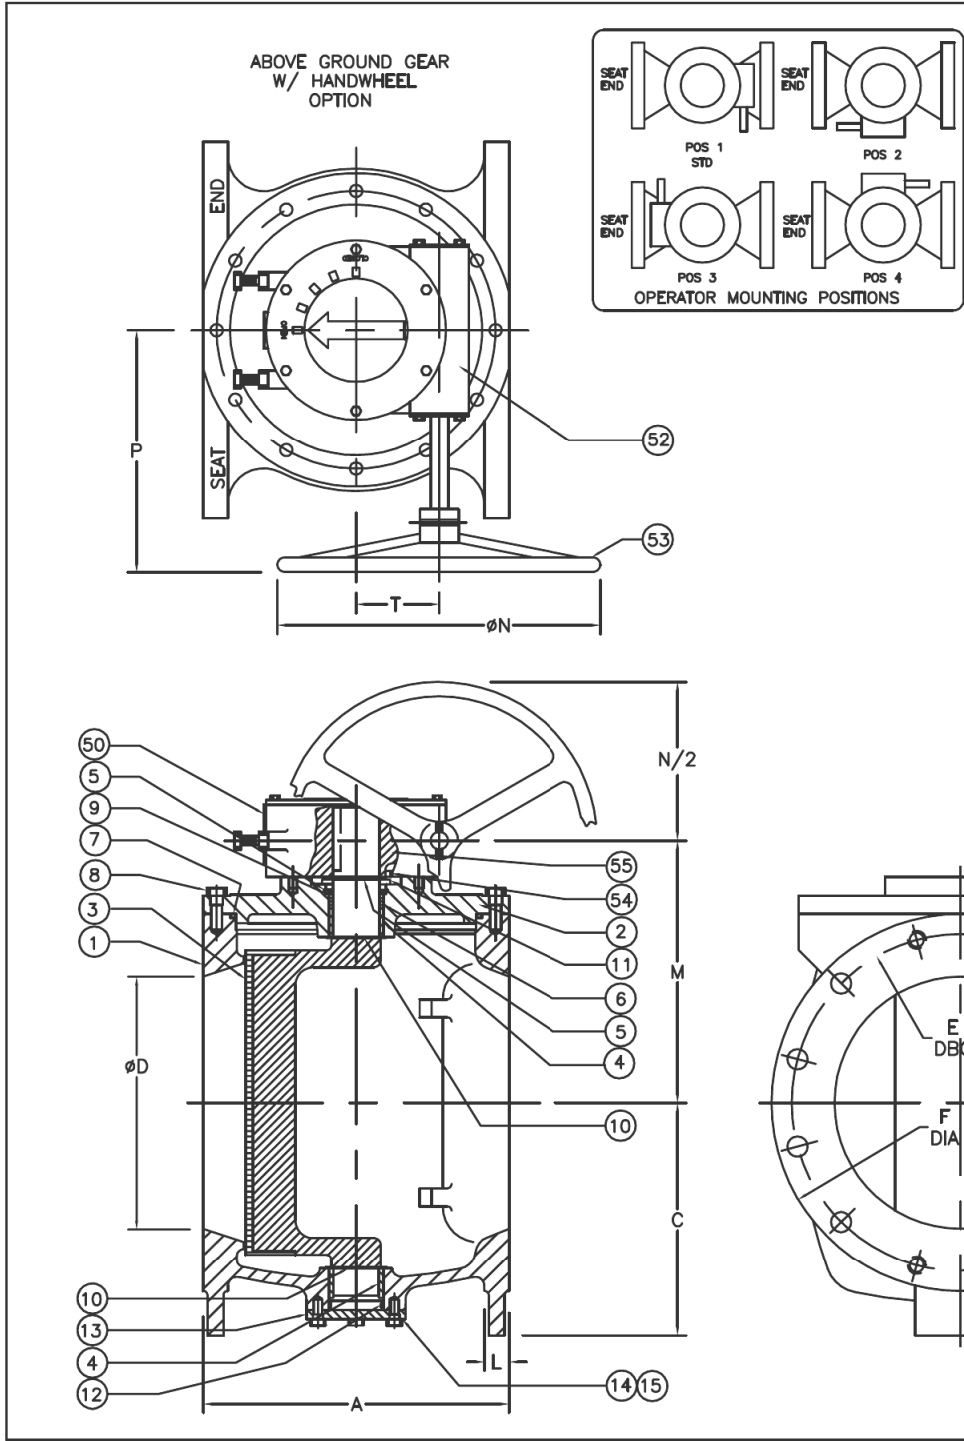

VALVE SIZE	A	C	D	E	F	G	H	J	K	L	M	N	P	T	FLANGE STYLE	GEAR SIZE
14	17	13	14	18.75	21	1.13	8	1	4	1.13	15.06	18	11.63	4.75	CL125	M80
16	17.75	14	16	21.25	23.25	1.13	8	1	8	1.44	15.81	18	11.63	4.75	CL125	M80
18	21.50	15	18	22.75	25	1.25	8	1.13	8	1.56	17	18	11.63	4.75	CL125	M80
20	23.50	16	20	25	27.50	1.25	12	1.13	8	1.69	20.44	18	11.63	4.75	CL125	M80

REFERENCE ONLY

55	1	QUADRANT	DUCTILE IRON
54	2	SLEEVE BEARING	BRONZE
53	1	HANDWHEEL	DUCTILE IRON
52	1	WORM GEAR	STEEL
50	1	HOUSING	CAST IRON
15	AR	LOCKWASHER	STEEL/ZINC
14	AR	CAP SCREW	STEEL/ZINC
13	1	TRUNION COVER	CAST IRON
12	1	O RING	ELAS. AS SPEC.
11	1	SUPPORT WASHER	STEEL
10	2	WASHER	PTFE
9	1	WASHER	BRASS
8	AR	CAP SCREW	STEEL/ZINC
7	1	O RING	ELAS. AS SPEC.
6	2	U CUP SEALS	ELAS. AS SPEC.
5	2	RETAINING RING	SPRING STEEL
4	2	SLEEVE BEARING	316 STN. STEEL
3	1	PLUG ELASTOMER AS SPEC.	DUCTILE IRON
2	1	CAP	A126 CL B
1	1	BODY	A126 CL B

ITEM	QTY.	DESCRIPTION	MATERIAL
55	1	QUADRANT	DUCTILE IRON
54	2	SLEEVE BEARING	BRONZE
53	1	HANDWHEEL	DUCTILE IRON
52	1	WORM GEAR	STEEL
50	1	HOUSING	CAST IRON
15	AR	LOCKWASHER	STEEL/ZINC
14	AR	CAP SCREW	STEEL/ZINC
13	1	TRUNION COVER	CAST IRON
12	1	O RING	ELAS. AS SPEC.
11	1	SUPPORT WASHER	STEEL
10	2	WASHER	PTFE
9	1	WASHER	BRASS
8	AR	CAP SCREW	STEEL/ZINC
7	1	O RING	ELAS. AS SPEC.
6	2	U CUP SEALS	ELAS. AS SPEC.
5	2	RETAINING RING	SPRING STEEL
4	2	SLEEVE BEARING	316 STN. STEEL
3	1	PLUG ELASTOMER AS SPEC.	DUCTILE IRON
2	1	CAP	A126 CL B
1	1	BODY	A126 CL B

PRATT
Henry Pratt Company

BY CR
CHK'D

DATE 10/95
SCALE NONE

REVISIONS

BY

DATE

TITLE:
14"-20"
PLUG VALVE FLANGED
GEAR OPERATED W/
HANDWHEEL

DWG. NO.
HP49036

THIS DRAWING IS THE PROPERTY OF
HENRY PRATT COMPANY
AND MUST NOT BE USED IN ANY WAY
PREJUDICIAL TO THEIR INTERESTS

Job No. 647979
Designed MFM
Drawn JD
Checked JZ
Reviewed JZ
Approved JZ
Reg. No. 25118
Plot Date 12-18-14

60% SUBMITTAL
NOT FOR
CONSTRUCTION

PREPARED BY:
PARSONS
222 SOUTH MILL AVENUE
SUITE #220
TEMPE, ARIZONA 85281
(602)952-9195
(602)952-9303 fax

PIMA
MARICOPA
IRRIGATION
PROJECT
P.O. BOX C
ROUTE A STREET
SACATON, AZ 85147
(520)562-6700
(520)562-6791 FAX

REACHES WS-1E AND WS-1F


PLUG VALVE 18"

DRAWING NAME
M-2.0




By
Date
Rev
Description

NOTES:
1. MANUFACTURER'S DATA SHEET (HENRY PRATT COMPANY)

REFERENCE ONLY

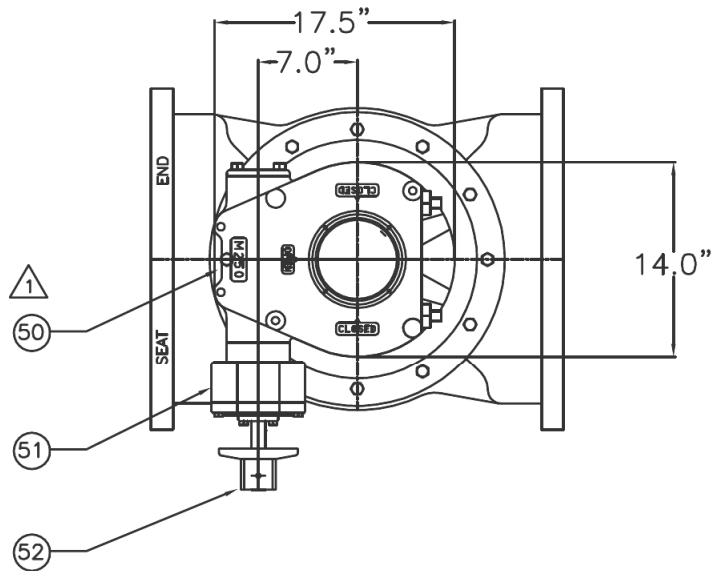


DRAWINGS ARE FOR
INFORMATION PURPOSES ONLY;
PLEASE REQUEST CERTIFIED DRAWINGS
BEFORE PREPARING PIPING DIAGRAMS

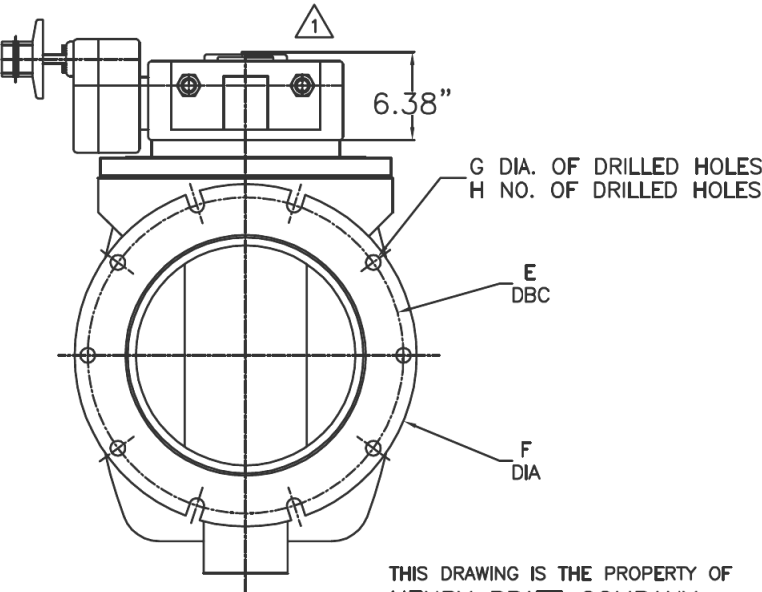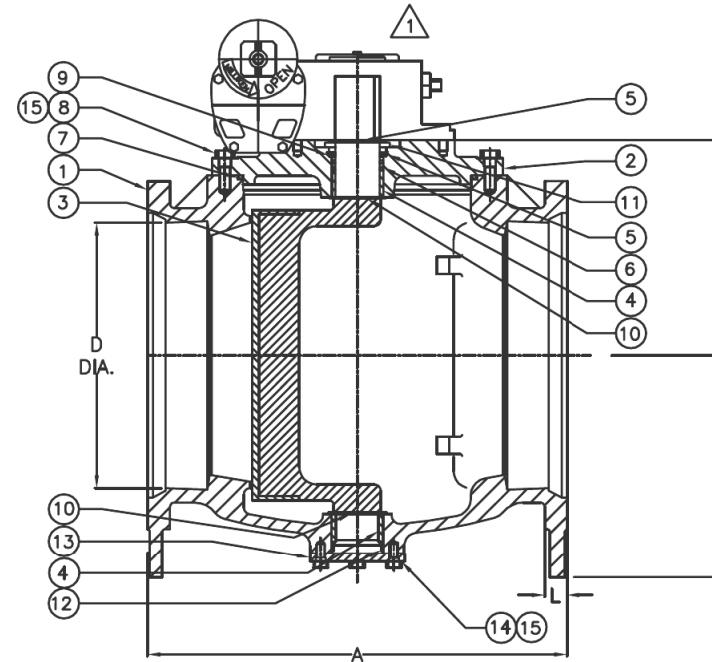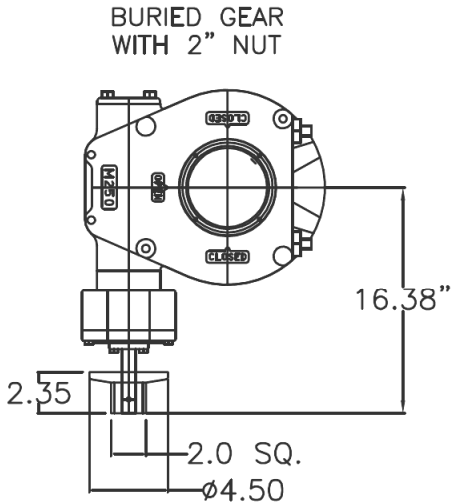

THIS DRAWING IS THE PROPERTY OF
HENRY PRATT COMPANY
AND MUST NOT BE USED IN ANY WAY
PREJUDICIAL TO THEIR INTERESTS

VALVE SIZE	A	B	C	D	E	F	G	H	L
24	42	19.38	21.63	24	30.00	31.50	0.88	16	1.88
30	51	23.44	24.75	30	36.88	39.13	1.13	20	2.12

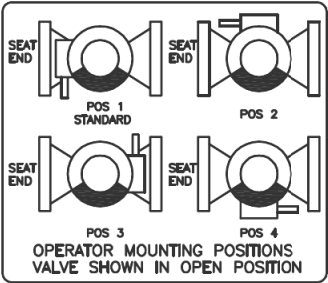

52	1	2" NUT	DUCTILE IRON
51	1	SPUR GEAR	—
50	1	GEAR OPERATOR	—
15	AR	LOCKWASHER	STEEL/ZINC
14	AR	CAP SCREW	STEEL/ZINC
13	1	TRUNION COVER	A 126 CL B
12	1	O RING	ELAS. AS SPEC.
11	1	SUPPORT WASHER	STEEL
10	2	GRIT SEAL	PTFE
9	1	WASHER	STEEL
8	AR	CAP SCREW	STEEL/ZINC
7	1	O RING	ELAS. AS SPEC.
6	2	U CUP SEALS	ELAS. AS SPEC.
5	2	RETAINING RING	SPRING STEEL
4	2	SLEEVE BEARING	BRONZE/SS
3	1	PLUG ELASTOMER AS SPEC.	A 126 CL B
2	1	CAP	A 126 CL B
1	1	BODY	A 126 CL B

ITEM		QTY.	DESCRIPTION	MATERIAL		
ISSUE NUMBER	PRATT HENRY PRATT COMPANY			BY	DATE	SCALE
				06/09		NONE
				CHK'D	DIMENSIONS	
				INCHES		
	DATE	REVISIONS		BY	TITLE: 24"–30" PLUG VALVE, MJ ENDS MIN. 80% PORT w/ M250 GEAR DWG. NO. HP49858	
1	07/09	REVISED GEAR & ADDED 30" VALVE DIMENSIONS [ECR# 164]		JC		

Job No. 647979
Designed MFM
Drawn JD
Checked JZ
Reviewed JZ
Approved JZ
Reg. No. 25118
Plot Date 12-18-14

60% SUBMITTAL
NOT FOR
CONSTRUCTION

PREPARED BY:
PARSONS
222 SOUTH MILL AVENUE
SUITE #220
TEMPE, ARIZONA 85281
(602)952-9195
(602)952-9303 fax

**PIMA
MARICOPA
IRRIGATION
PROJECT**
P.O. BOX C, ROUTE A STREET
SACATON, AZ 85147
(520)562-6700
(520)562-6791 FAX


REACHES WS-1E AND WS-1F

PLUG VALVE 24" AND 30"

DRAWING NAME
M-2.1

By
Date
Rev
Description


NOTES:
1. MANUFACTURER'S DATA SHEET (HENRY PRATT COMPANY)

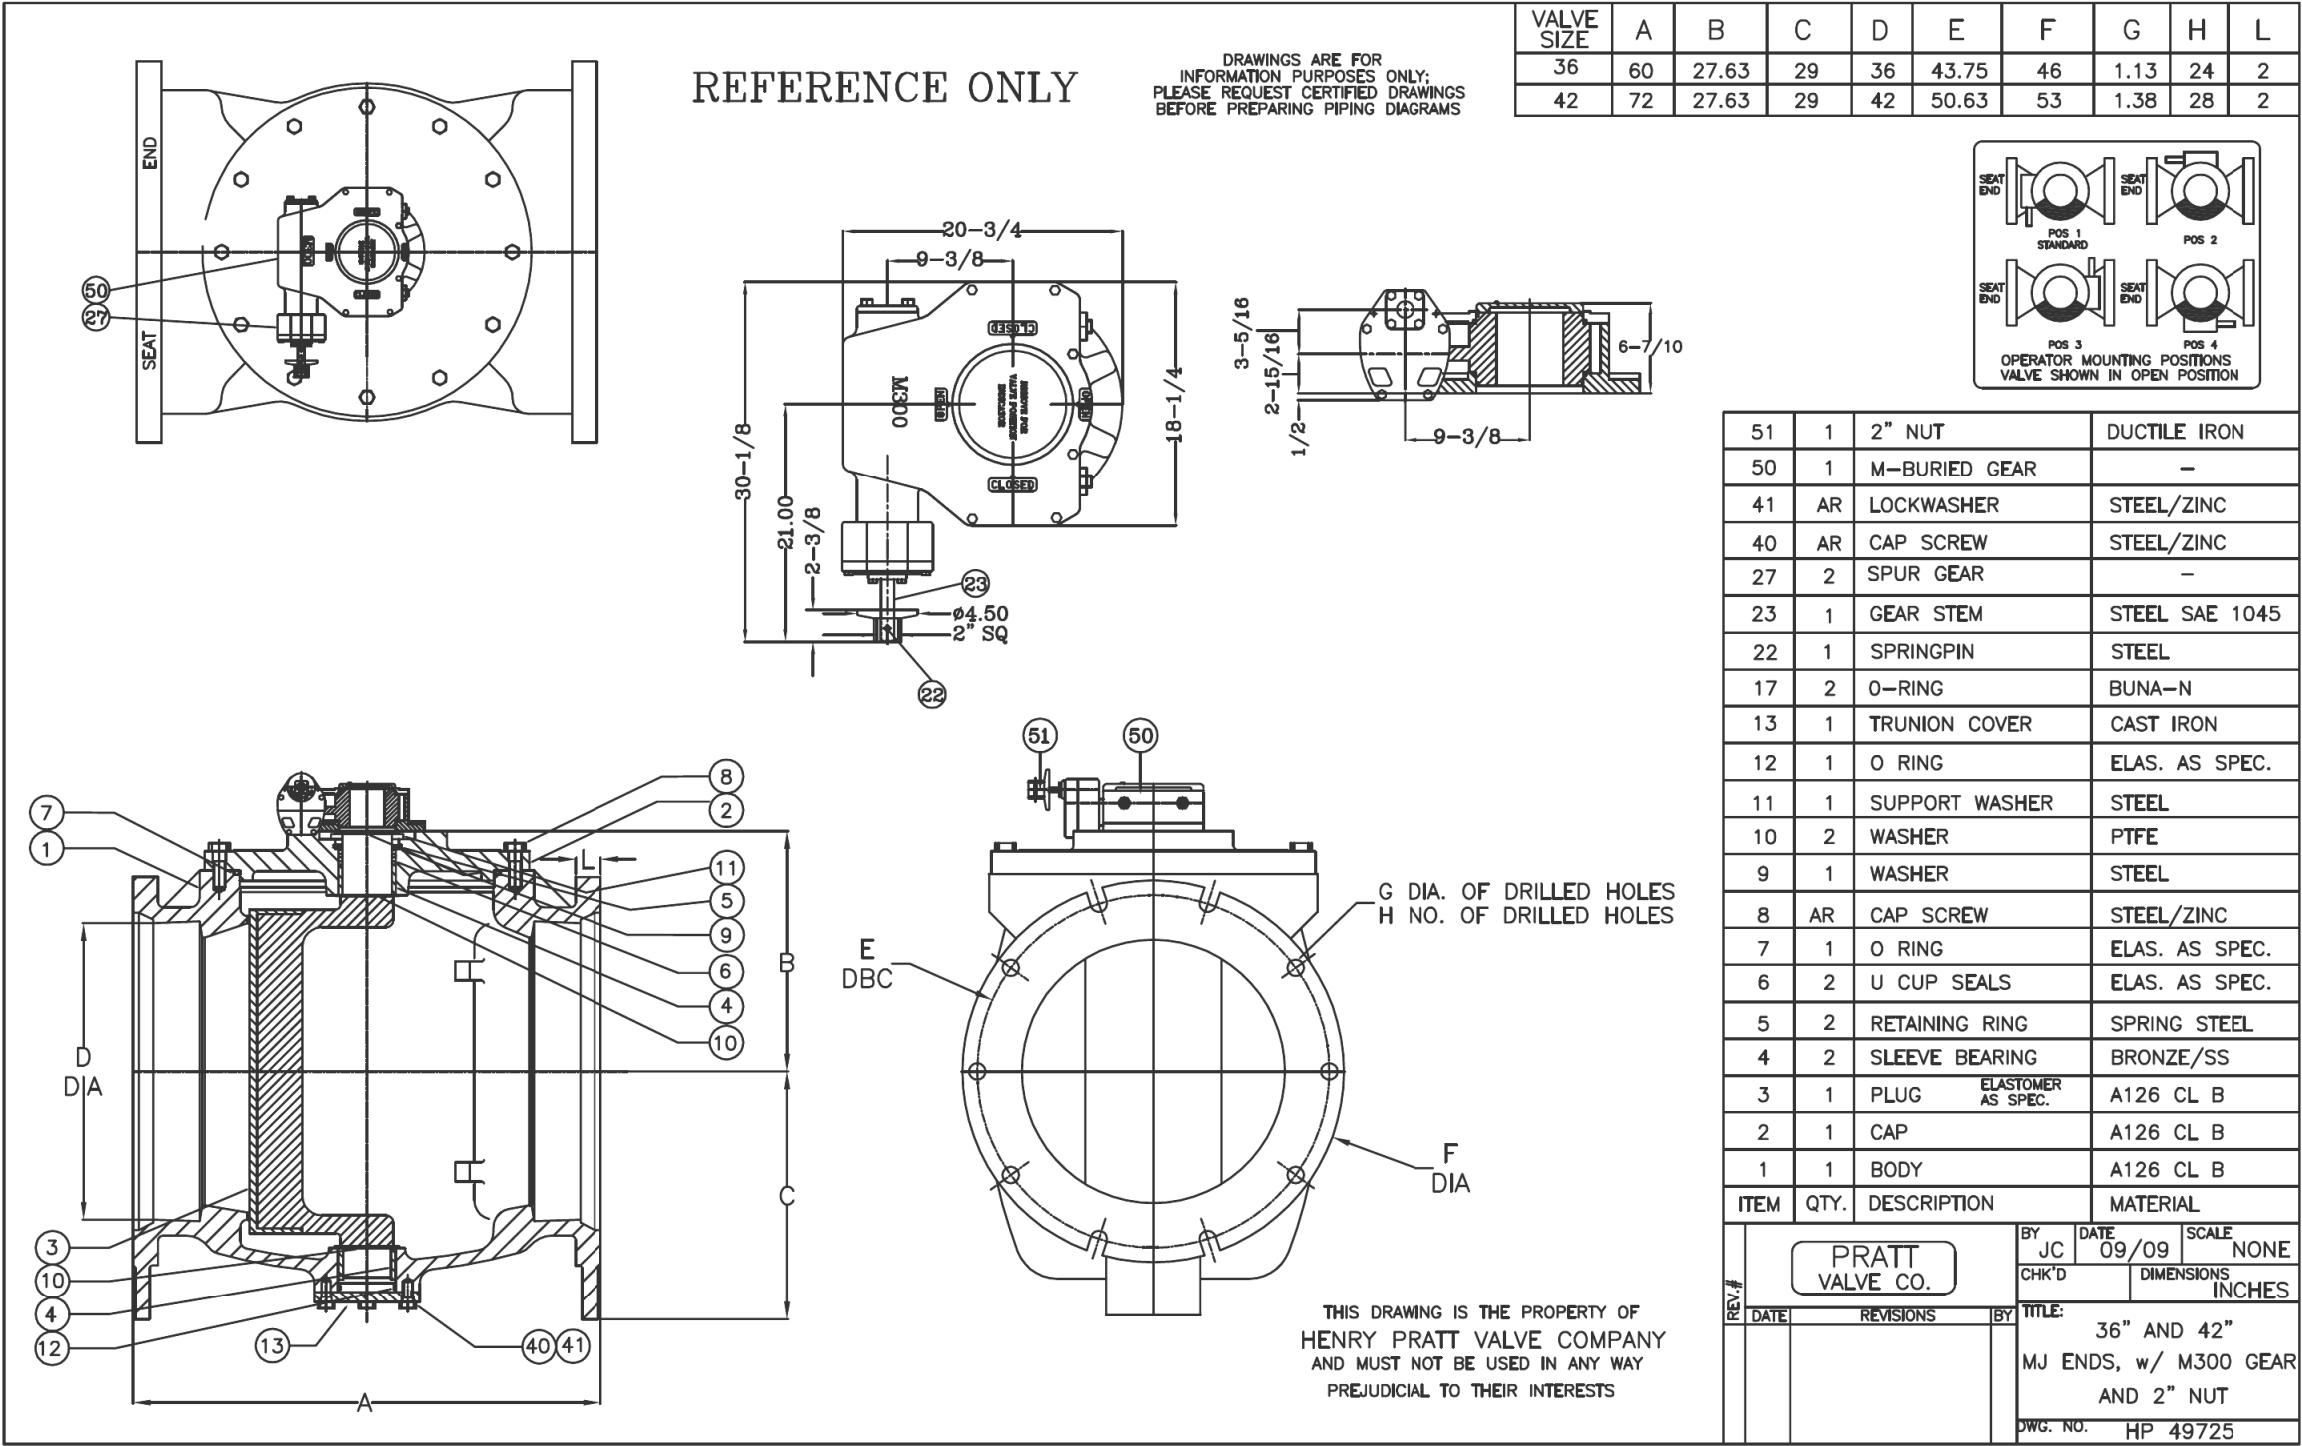

Job No.	647979	Designed	MFM	Drawn	JD	Checked	JZ	Reviewed	JZ	Approved	JZ	Reg. No.	25118	Plot Date	12-18-14	Rev	Date	Description	By
																			60% SUBMITTAL NOT FOR CONSTRUCTION
																			PREPARED BY: PARSONS 222 SOUTH MILL AVENUE SUITE #220 TEMPE, ARIZONA 85281 (602)952-9195 (602)952-9303 fax
																			 PIMA MARICOPA IRRIGATION PROJECT P.O. BOX C ROUTE A STREET SACATON, AZ 85147 (520)562-6700 (520)562-6791 FAX
																			REACHES WS-1E AND WS-1F
																			PLUG VALVE 36" AND 42"
																			DRAWING NAME M-2.2

NOTES:

1. MANUFACTURER'S DATA SHEET (HENRY PRATT COMPANY)

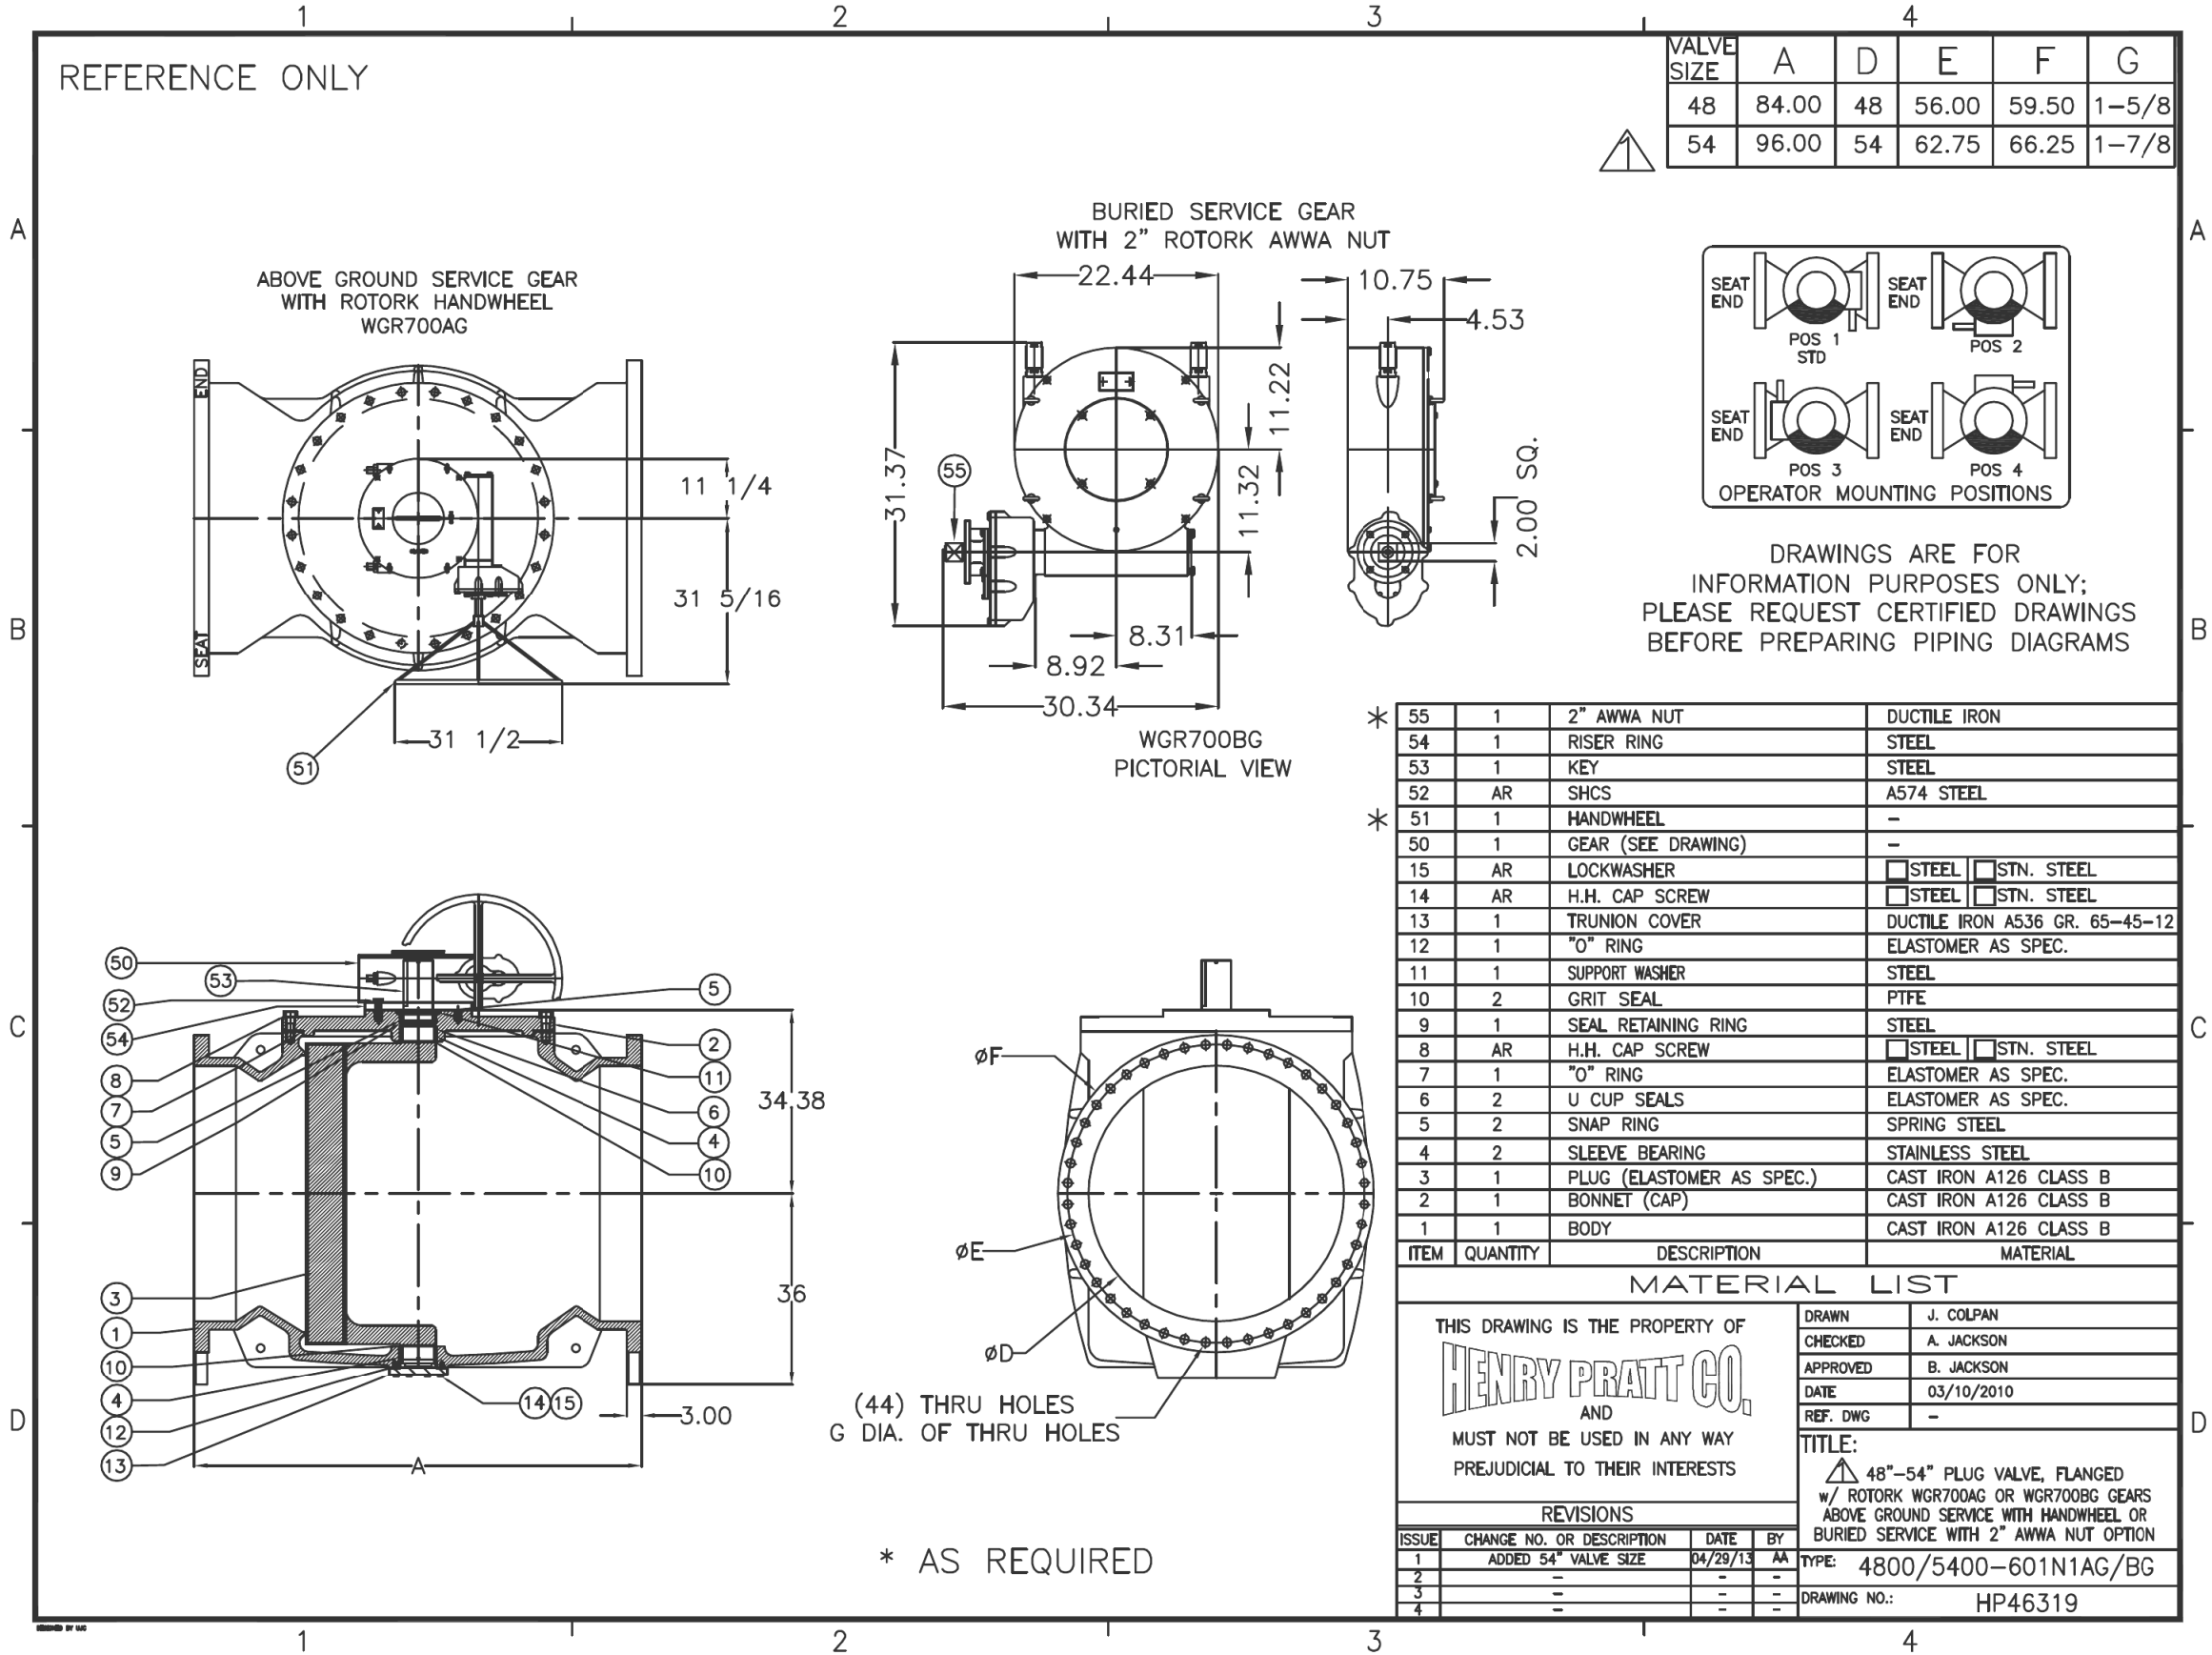

Job No.	647979	Designed	MFM	Drawn	JJD	Checked	JZ	Reviewed	JZ	Approved	JZ	Reg. No.	25118	Plot Date	12-18-14	Rev	Date	Description	By
60% SUBMITTAL NOT FOR CONSTRUCTION																			
PREPARED BY: PARSONS 222 SOUTH MILL AVENUE SUITE #220 TEMPE, ARIZONA 85281 (602)952-9195 (602)952-9303 fax																			
PIMA MARICOPA IRRIGATION PROJECT P.O. BOX C ROUTE A STREET SACATON, AZ 85147 (520)562-6700 (520)562-6791 FAX																			
REACHES WS-1E AND WS-1F PLUG VALVE 48" AND 54"																			
DRAWING NAME M-2.3																			



Size	L	Ød	ØG	ØC	N	NCP	T	ØW	H
3	2.00	2.68	5.00	6.00	4	5/8"-11	0.236	7.09	15.75
4	2.00	3.54	6.18	7.50	8	5/8"-11	0.276	7.87	18.90
6	2.25	5.43	8.50	9.50	8	3/4"-10	0.315	9.84	24.41
8	2.75	7.32	10.63	11.75	8	3/4"-10	0.315	11.81	31.50
10	2.75	9.21	12.76	14.25	12	7/8"-9	0.394	13.78	37.80
12	3.00	11.10	15.00	17.00	12	7/8"-9	0.394	15.75	43.31
14	3.00	12.72	16.26	18.75	12	1"-8	0.472	17.72	48.82
16	3.50	14.25	18.50	21.25	16	1"-8	0.472	19.69	53.94
18	3.50	16.22	20.98	22.75	16	1-1/8"-7	0.472	19.69	60.24
20	4.50	18.19	22.99	25.00	20	1-1/8"-7	0.591	21.65	67.72
24	4.50	21.85	27.24	29.50	20	1-1/4"-7	0.591	21.65	79.13

Job No.	647979
Designed	MFM
Drawn	JD
Checked	JZ
Reviewed	JZ
Approved	JZ
Reg. No.	25118
Plot Date	12-18-14

**60% SUBMITTAL
NOT FOR
CONSTRUCTION**

PREPARED BY:

PARSONS

222 SOUTH MILL AVENUE
SUITE #220
TEMPE, ARIZONA 85281
(602)852-9195
(602)952-9303 fax



**PIMA
MARICOPA
IRRIGATION
PROJECT**
P.O. BOX C
192-A SOUTH ROUTE A STREET
SACATON, AZ 85147
(520)562-6700
(520)562-6791 FAX

REACHES WS-1E AND WS-1F

KNIFE GATE VALVE

DRAWING NAME	M-3.0
--------------	-------

By

NOTES:

1. MANUFACTURER'S DATA SHEET (CLA-VAL™)



Series 33A

Sizes 1" - 2" - 3" - 4" - 6"

Air Release & Vacuum Breaker Valve (Threaded & Flanged)



Threaded



Flanged

- Automatically Eliminates Air Pockets
- Easily Serviced Without Removal from Pipeline
- Simple, Effective Patented Design
- Corrosion Resistant Materials of Construction
- Engineered For Lasting Service

Designed to protect pipelines and vertical turbine pump applications on offshore platforms from air lock and vacuum collapse, the Cla-Val Model 33A Air Release and Vacuum Breaker Valve eliminates air and prevents vacuum formations in pipelines. A large venting orifice and large float clearances freely exhaust or admits air during pipeline filling or draining.

During normal pipeline operation, air accumulation and buoyancy cause the float ball to lower or lift. As the water level lowers inside the valve, small amounts of accumulated air are released through the small orifice. Once air is released, the patented float poppet system closes drip tight.

Valve servicing is simple because the entire float poppet system, can be replaced without removal of the valve body from the pipeline.

Typical Applications

- Standard Max. D.W.P. 300 psi (For Higher Operating Pressures Consult Factory)
- Transmission Pipeline High Points
- Water Treatment Plant Piping High Points
- Offshore Platforms
- Vertical Turbine Pump Discharge

Installation

Series 33A Air Release and Vacuum Breaker Valves are typically installed at high points in pipelines for air release, or at anticipated pipeline vacuum occurrence locations. Install Series 33A at regular intervals (approximately 1/2 mile) along uniform grade line pipe. Mount the unit in the vertical position on top of the pipeline, and include an isolation/shutoff valve.

Series 33A is often installed upstream of check valves in pump discharges to vent air during start-up and to allow air reentry when the pump stops.


Operation

Air Release Mode—Valve is normally open.

When line is filled or pump started, air is exhausted through the normally open 33A valve. As liquid fills the valve, float ball rises to form a drip-tight closure and remaining air is exhausted through small orifice.

Vacuum Prevent Mode When line pressure drops below positive pressure and the liquid level lowers, the float drops, unseating the valve and allowing air into the line, thus preventing a vacuum.

Note: Available for Sea Water Service See Material Specifications

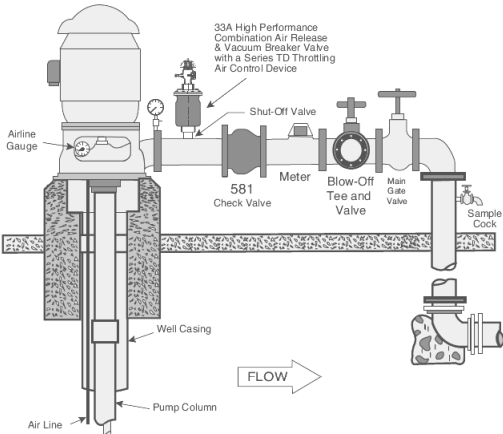

Dimensions (In Inches)

Valve Size	33A Pressure Class 300 Lb Threaded				33A Pressure Class 150 Lb Flanged (INLET)			
	1"	2"	3"	4"	2"	3"	4"	6"
A	9.10	12.44	12.75	12.75	13.88	15.56	15.75	16.38
B	6.25	7.50	9.00	9.00	7.50	9.25	9.25	11.00
E	—	—	—	—	.62	.75	.94	1.00
Inlet (ANSI)	1" NPT	2" NPT	3" NPT	4" NPT	2"	3"	4"	6"
Outlet (NPT)	1" NPT	2" NPT	3" NPT	4" NPT	2"	3"	4"	6"
Number of Holes	—	—	—	—	4	4	8	8
Diameter of Bolts	—	—	—	—	.63	.63	.75	.75
Shipping Wt. (Lb.)	25	29	38	40	39	48	50	70

Pressure Ratings

Valve Size	Orifice Dia.	Standard Maximum Pressure	Materials of Construction
1"	.076"	300 psi	• Ductile Iron ASTM A536 65-45-12
2"	.076"	300 psi	• Epoxy Coated Cast Steel ASTM A 216WCB
3" & 4"	.125"	300 psi	• ASTM B61 Naval Bronze
3" & 4"	.076"	300 psi	• ASTM B 148 NI Aluminum Bronze
6"	.076"	300 psi	• 316 Stainless Steel
			• Duplex Stainless Steel
			• Super Duplex Stainless Steel

Note: Higher Pressures Available upon Request

Specifications

Standard Internals

Float: Stainless Steel 304SS Standard, T316 or Monel optional (extra cost)

Balance internals parts Stainless Steel and Delrin

Seals Nitrile Rubber or Viton® (extra cost)

Temperature Range

Water to 180° F


Optional:

1. Fusion epoxy lined and coated
2. For Well Service Throttling Device on the Outlet Specify Model TD

Valve Sizing Selection



Large Orifice Air-Vacuum Capacity

Determine anticipated water flow and allowable pressure differential for the pipeline application. Select valve from chart to exhaust or admit air at the same rate as water filling or draining (in CFS). For larger flows, two or more Model 33A's may be installed in parallel

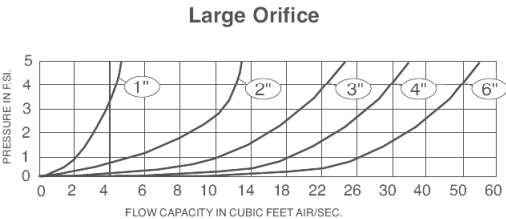


Note: For sizing made easy request:
Cla-Val Selector Slide Rule

MODEL 33A - 1", 2", 3", 4" and 6" Sizes

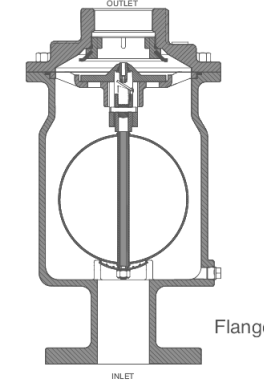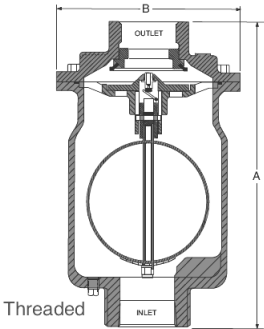

Small Orifice Capacity

During pressurized pipeline operation, small pockets of entrapped air will be released through the float actuated 0.076 or .125 inch orifice. Use chart to determine discharge capacity.

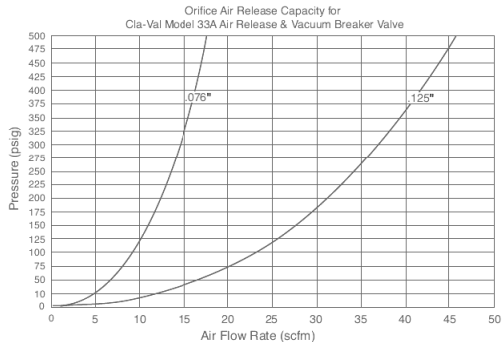

P.O. Box 1325 • Newport Beach, CA 92659-0325 • Phone: 949-722-4800 • Fax: 949-548-5441 • E-mail: claval@cla-val.com • Website cla-val.com
© Copyright Cla-Val 2013 Printed in USA Specifications subject to change without notice. E-33A Threaded & Flanged (R-04/2013)

Job No. 647979
Designed MFM
Drawn JD
Checked JZ
Reviewed JZ
Approved JZ
Reg. No. 25118
Plot Date 12-18-14

60% SUBMITTAL
NOT FOR
CONSTRUCTION

PREPARED BY:
PARSONS
222 SOUTH MILL AVENUE
SUITE #220
TEMPE, ARIZONA 85281
(602)952-9195
(602)952-9303 fax

PIMA
MARICOPA
IRRIGATION
PROJECT
P.O. BOX C
ROUTE A STREET
SACATON, AZ 85147
(520)562-6700
(520)562-6791 FAX


REACHES WS-1E AND WS-1F

ARV

DRAWING NAME
M-4.0

By

Dimensional Data

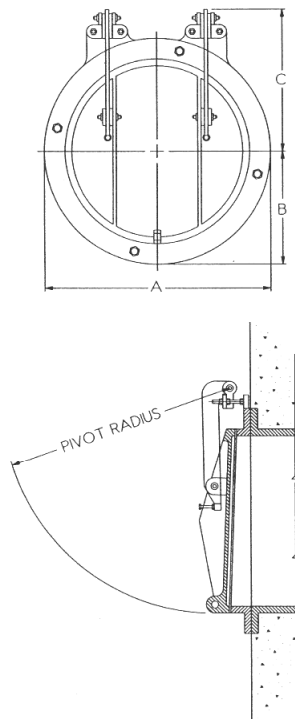

Model 50C Round Opening
for Heads to 50 Ft

Opening Size Dia. (In.)	Dimensions (In.)			Pivot Radius (In.)
	A	B	C	
4	9.00	4.50	5.25	7.31
6	11.00	5.50	8.25	11.75
8	13.50	6.75	9.50	14.00
10	16.00	8.00	9.75	15.25
12	19.00	9.50	10.25	16.75
14	21.25	10.63	12.50	19.75
15	22.25	11.13	12.50	20.31
16	23.50	11.75	13.00	21.25
18	24.75	12.50	15.75	25.00
20	27.50	13.75	16.25	26.25
21	28.00	14.00	16.50	27.38
24	32.00	16.00	19.25	31.25
27	34.75	17.38	21.25	36.00

Opening Size Dia. (In.)	Dimensions (In.)			Pivot Radius (In.)
	A	B	C	
30	38.75	19.38	23.25	38.50
36	46.00	23.00	27.50	45.50
42	53.00	26.50	32.50	53.50
48	59.50	29.75	37.75	61.75
54	66.25	33.25	39.75	67.25
60	73.00	36.50	46.00	76.00
66	80.00	40.00	50.00	83.00
72	86.50	43.25	54.25	90.00
78	93.50	46.75	58.25	97.00
84	100.00	50.00	62.25	104.25
90	106.50	53.25	65.50	111.25
96	113.25	56.63	65.50	117.25
108	125.00	62.50	75.13	129.75


Figure 6-2
Heavy-Duty Flap Gate (Model 50C)

Model 50 Square and Rectangular
Openings for Heads to 50 Ft

Opening Dia. (In.)	Dimensions (In.)			Pivot Radius (In.)
	A	B	C	
12 x 12	18.00	9.00	11.25	18.25
18 x 18	25.00	12.50	15.75	25.00
24 x 24	32.00	15.00	19.25	31.25
30 x 18	37.00	12.50	15.75	25.00
30 x 30	40.50	18.75	25.75	40.25
36 x 24	44.00	16.00	21.00	31.25
36 x 36	44.00	22.00	27.50	45.25
42 x 30	52.00	19.25	23.25	38.25
42 x 42	52.00	25.00	32.50	53.25
48 x 24	56.00	16.00	19.00	29.25
48 x 36	56.00	22.00	27.50	46.50
48 x 48	58.00	29.00	37.75	61.75
54 x 36	63.00	22.50	27.50	47.50
54 x 54	64.00	32.00	39.75	66.75
60 x 30	68.00	19.00	24.25	39.75

Opening Dia. (In.)	Dimensions (In.)			Pivot Radius (In.)
	A	B	C	
60 x 36	70.00	23.00	29.00	48.75
60 x 48	70.00	29.00	37.75	61.75
60 x 60	70.00	35.00	45.75	75.75
66 x 42	76.00	26.00	32.75	53.50
66 x 66	76.00	38.00	52.00	85.00
72 x 48	82.00	29.00	37.75	61.75
72 x 60	82.00	35.00	45.75	75.75
72 x 72	82.00	41.00	54.75	90.50
84 x 60	94.00	35.00	46.00	75.75
84 x 84	94.00	47.00	62.25	104.00
96 x 60	108.00	36.00	46.00	76.00
96 x 84	108.00	48.00	62.50	104.00
96 x 96	108.00	54.00	69.00	117.00
108 x 108	120.00	60.00	76.00	138.00
120 x 120	132.00	60.00	81.00	149.00

Figure 6-3
Heavy-Duty Flap Gate (Model 50)

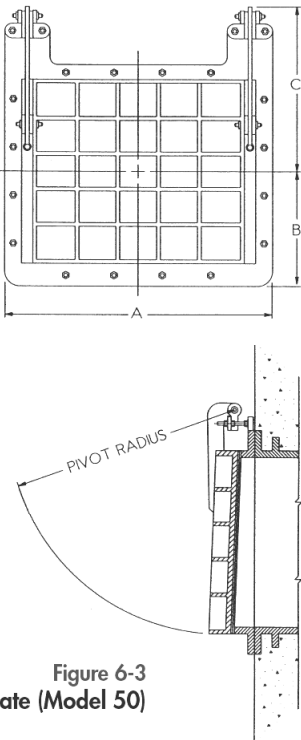

NOTES:
1. MANUFACTURER'S DATA SHEET (HYDRO GATE)

Job No. 647979
Designed MFM
Drawn JD
Checked JZ
Reviewed JZ
Approved JZ
Reg. No. 25118
Plot Date 12-18-14

60% SUBMITTAL
NOT FOR
CONSTRUCTION

PREPARED BY:
PARSONS
222 SOUTH MILL AVENUE
SUITE #220
TEMPE, ARIZONA 85281
(602)952-9195
(602)952-9303 fax


**PIMA MARICOPA
IRRIGATION
PROJECT**
P.O. BOX C
ROUTE A STREET
SACATON, AZ 85147
(520)562-6700
(520)562-6791 FAX

REACHES WS-1E AND WS-1F
FLAP GATE DETAIL

DRAWING NAME
M-5.0


By
Date
Rev
Description

FABRIC HEIGHT	TYPICAL POST DIMENSIONS						
	CORNER, END, INTERMEDIATE, GATE, LATCH AND PULL POSTS				LINE POSTS		
	ROUND	ROLL FORMED	ROLL FORMED	ROLL FORMED	ROUND	H-SECTION	ROLL FORMED
72"	9'-0"	2.375'	3.50"x3.50"	2.25"x1.70"	8'-6"	1.900"	1.875"x1.625"

TYPICAL GATE DIMENSIONS		
GATE LEAF WIDTH	VERTICAL BRACES	GATE POST SIZE
H	0	OD
3' TO 8'	0	2.8750"
8' TO 16'	1	4.0000"


GENERAL NOTES:

- POSTS SHALL BE ROUND, H-SECTION, OR ROLL-FORMED AND SHALL CONFORM TO THE NORMAL DIMENSIONAL REQUIREMENTS SHOWN. DIMENSIONAL TOLERANCES FOR TOLERANCES FOR ALL SHAPES SHALL BE ACCORDING TO ASTM A-500. IN ADDITION, THE MATERIAL OF WHICH POSTS ARE FABRICATED SHALL HAVE A NOMINAL THICKNESS, BEFORE GALVANIZING, OF NOT LESS THAN 0.111" FOR LINE POSTS AND 0.130" FOR TERMINAL POSTS.
- CHAIN LINK FABRIC SHALL BE EITHER ZINC-COATED OR ALUMINUM-COATED STEEL WIRE FENCE FABRIC. ZINC-COATED STEEL FABRIC SHALL CONFORM TO THE REQUIREMENTS OF ASTM A392, CLASS 1 COATING. ALUMINUM-COATED STEEL FABRIC SHALL CONFORM TO THE REQUIREMENTS OF ASTM A491, WITH A MINIMUM WEIGHT OF COATING OF 0.40 OUNCE PER SQUARE FOOT OF WIRE SURFACE AREA. FABRIC SHALL BE 9 GAUGE.
- TENSION WIRES SHALL BE 7 GAUGE (0.177 INCH DIAMETER) COIL SPRING STEEL WIRE WITH A MINIMUM TENSILE STRENGTH OF 75,000 PSI AND SHALL BE ZINC-COATED OR ALUMINUM-COATED.
- ADJUSTABLE TRUSS RODS SHALL BE 3/8 INCH DIAMETER. TRUSS TIGHTENERS SHALL HAVE A STRAP THICKNESS OF NOT LESS THAN 1/4 INCH.
- STRETCHER BARS SHALL BE 3/16 INCH BY 3/4 INCH STEEL FLAT BARS. STRETCHER BAR BANDS SHALL BE 1/8 INCH BY ONE INCH PREFORMED STEEL BANDS.
- BOTTOM TENSION WIRE SHALL BE 3 INCHES FROM TOP OF CROWN ON CONCRETE FOOTINGS.
- INTERMEDIATE POST ASSEMBLIES SHALL BE SPACED AT 500 FOOT INTERVALS OR MIDWAY BETWEEN PULL POSTS WHEN THE DISTANCE BETWEEN SUCH POSTS IS LESS THAN 1,000 FEET AND MORE THAN 500 FEET.
- CONCRETE DESIGN STRENGTH: $f'c = 3,000$ PSI MIN.
- BARBED WIRE FOR USE WITH CHAIN LINK FENCE SHALL BE 3 STRANDS OF 12 1/2 GAUGE STEEL WIRE WITH 4 POINT 14 GAUGE BARBS SPACED 5 INCHES APART AND SHALL BE ZINC-COATED. ZINC-COATED STEEL WIRE SHALL CONFORM TO THE REQUIREMENTS OF ASTM A121, CLASS 1 COATING. SEE SPEC. 02444 ART 2.04.A. RODS SEE SPEC. SECTION 02444 ART 2.04.E.
- BARBED WIRE SUPPORT ARM SHALL BE FABRICATED FROM COMMERCIAL QUALITY STEEL, AND SHALL BE ZINC-COATED IN ACCORDANCE WITH THE REQUIREMENTS OF AASHTO M111.
- THE TYPICAL STRUCTURE CONNECTION DETAILS APPLY AT THE HEADWALLS OF INVERTED SIPHONS, RECTANGULAR INCLINE DROP STRUCTURES, AND CHECK STRUCTURE.
- FENCE OVERHANGS SHALL BE LOCATED AT ENDS OF CHAIN LINK FENCE AROUND STRUCTURES. FENCE OVERHANGS AT UPSTREAM END OF STRUCTURES SHALL BE LOCATED OR AS SHOWN ON PLANS.
- FOR SIGN DETAILS.
- INSTALL CHAIN LINK FENCE OFF OF LINING OR STRUCTURE WALLS AS SHOWN
- ANTI-THEFT SLATS THROUGH CHAIN LINK FENCE ARE REQUIRED
- SCORE BOLTS AFTER TIGHTENING TO PREVENT VANDALISM
- FENCE SHALL BE GROUNDED USING EMBEDDED PLATES, RODS OR OTHER APPROVED MEANS.

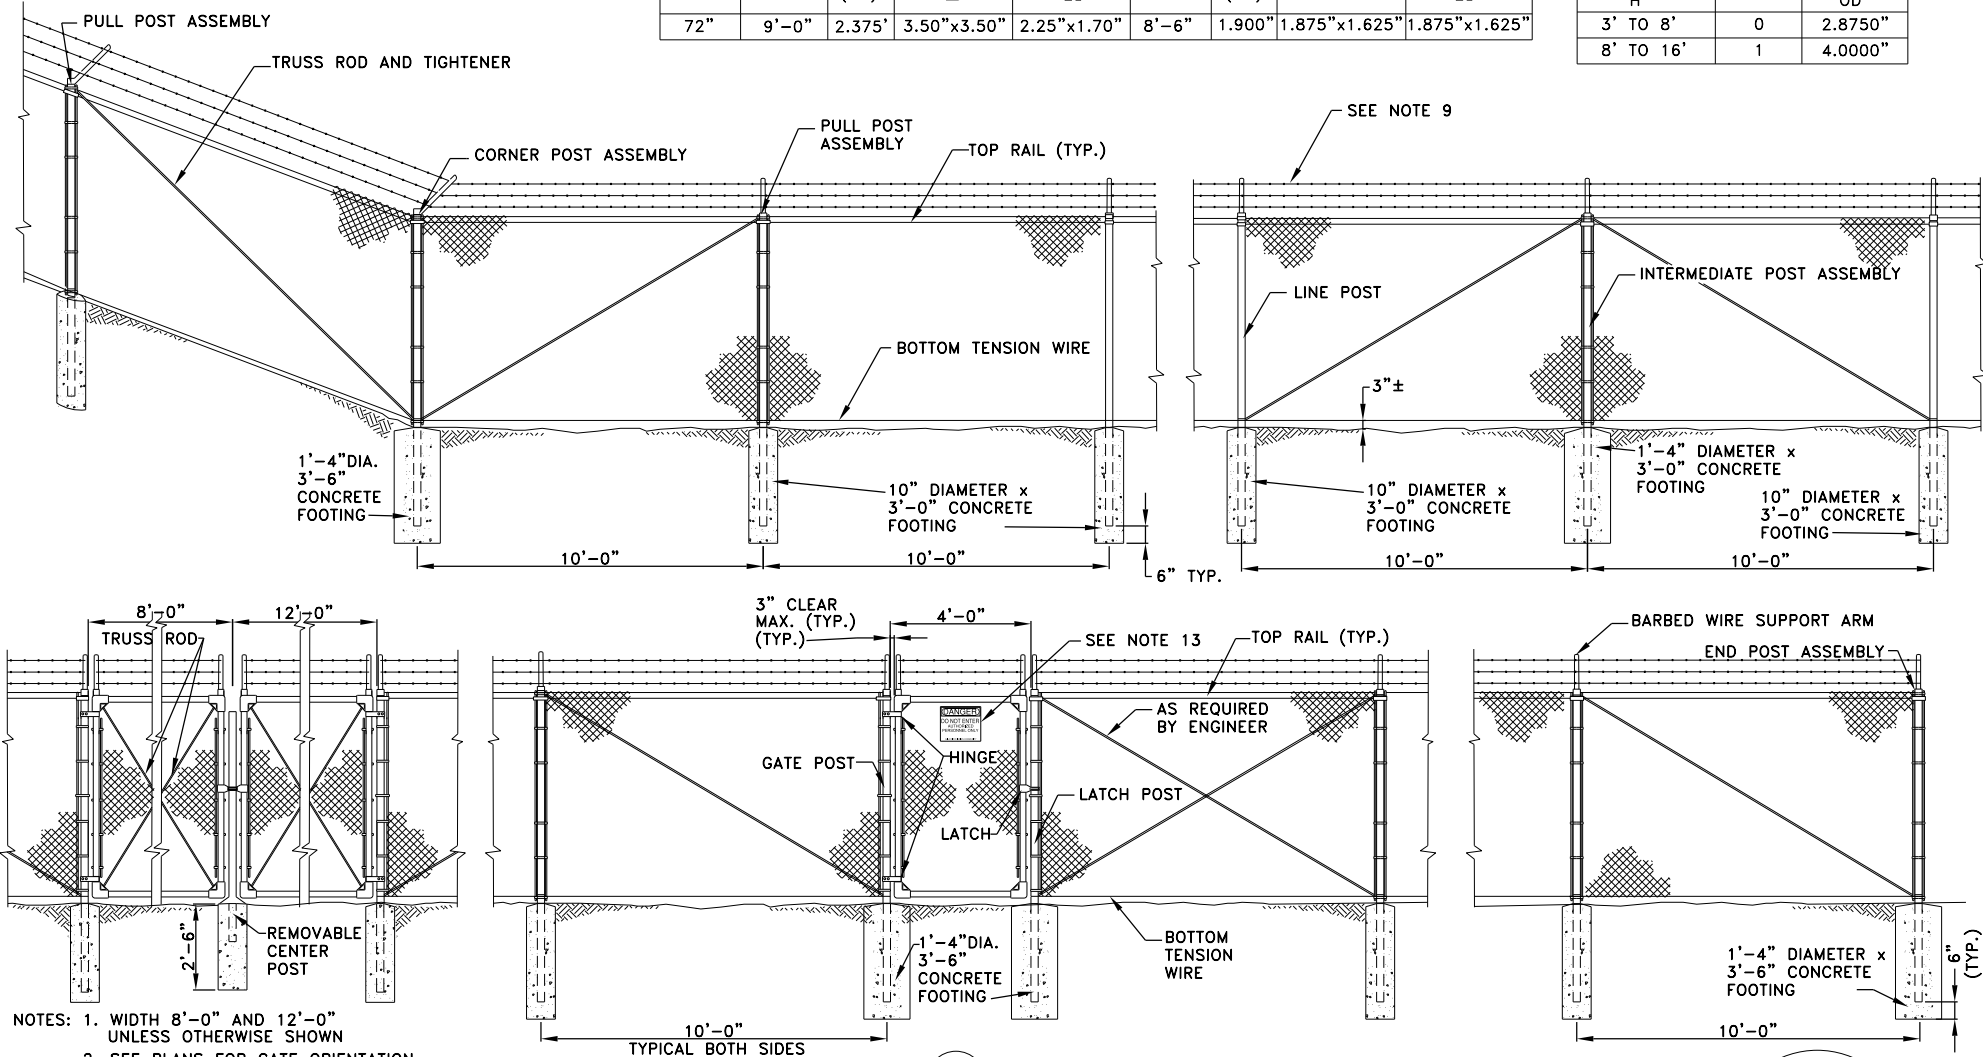

NOTES: 1. WIDTH 8'-0" AND 12'-0" UNLESS OTHERWISE SHOWN
2. SEE PLANS FOR GATE ORIENTATION


2 DOUBLE SWING GATE DETAIL
SCALE: 3/8"=1'-0"

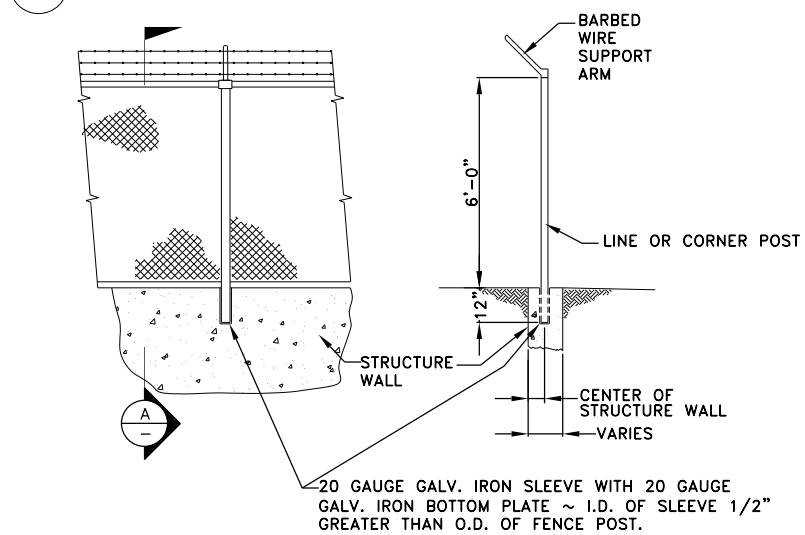

3 CHAIN LINK FENCE - TYPICAL STRUCTURE CONNECTION (FOR WALLS > 10" THICKNESS ONLY)
SCALE: 3/8"=1'-0"


A SECTION
SCALE: 3/8"=1'-0"

4 TYPICAL FENCE POST INSTALLATION ADJACENT TO LINING OR STRUCTURES
SCALE: 3/8"=1'-0"

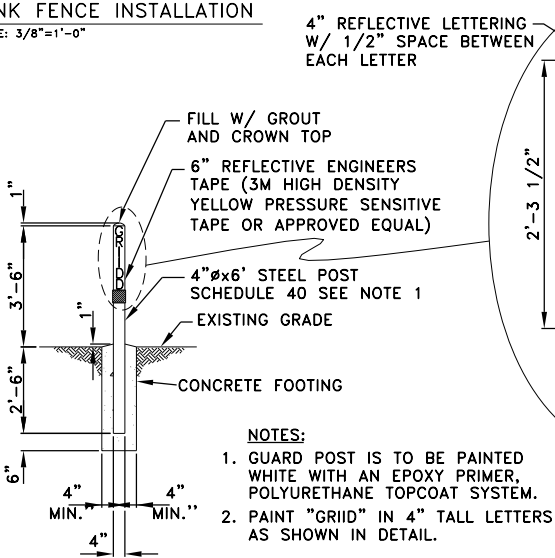


NOTES:
1. GUARD POST IS TO BE PAINTED WHITE WITH AN EPOXY PRIMER, POLYURETHANE TOPCOAT SYSTEM.
2. PAINT "GRID" IN 4" TALL LETTERS AS SHOWN IN DETAIL.

5 TYPICAL GUARD POST
SCALE: 3/4"=1'-0"

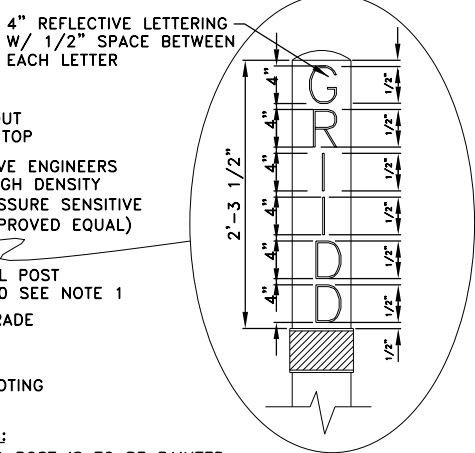

6 BARBED WIRE SUPPORT ARM
NO SCALE

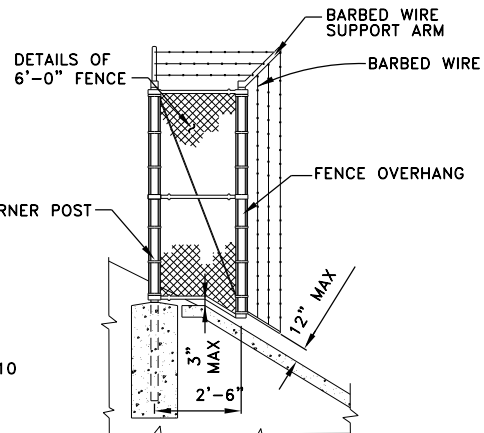

7 TYPICAL FENCE OVERHANG
SCALE: 3/8"=1'-0"

Job No. 647979
Designed MFM
Drawn JD
Checked JZ
Reviewed JZ
Approved JZ
Reg. No. 25118
Plot Date 12-18-14

60% SUBMITTAL
NOT FOR
CONSTRUCTION

PREPARED BY:
PARSONS
222 SOUTH MILL AVENUE
SUITE #220
TEMPE, ARIZONA 85281
(602)952-9195
(602)952-9303 fax





PIMA MARICOPA
IRRIGATION
PROJECT
P.O. BOX C, ROUTE A STREET
SACATON, AZ 85147
(520)562-6700
(520)562-6791 FAX

REACHES WS-1E AND WS-1F


CHAIN LINK FENCE AND GUARD POST DETAIL

DRAWING NAME
M-6.0


By
Date
Rev

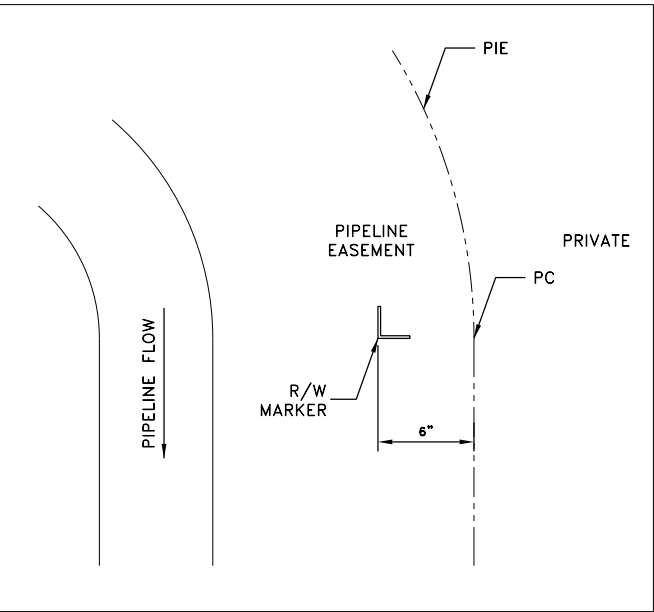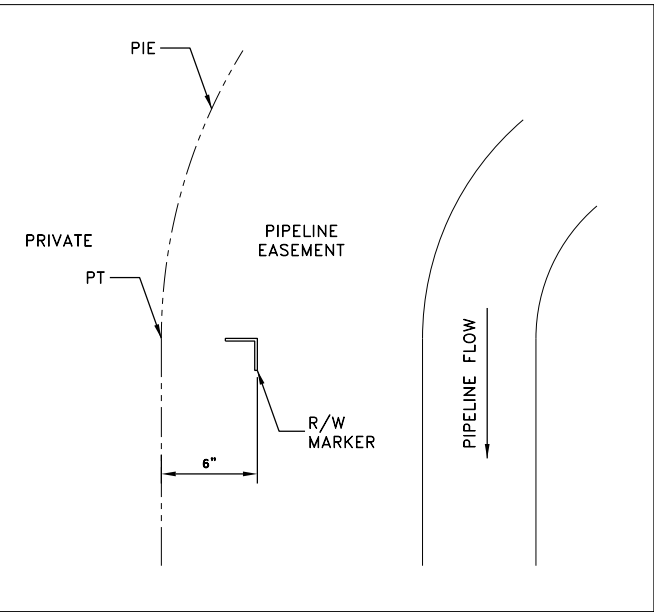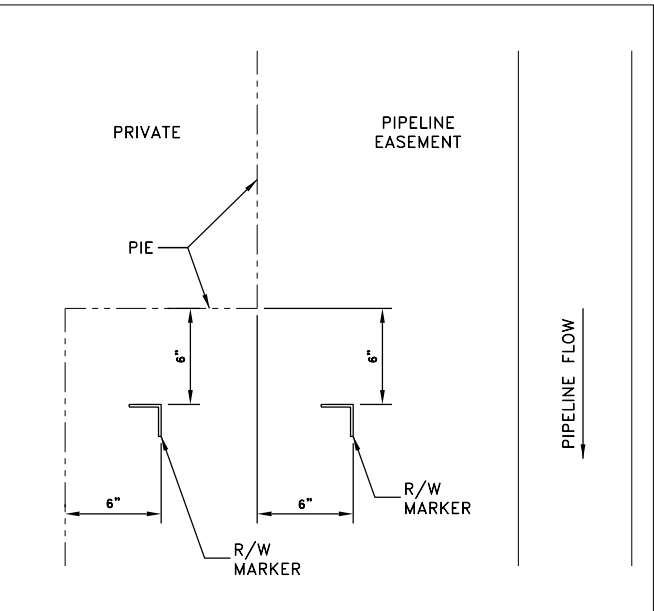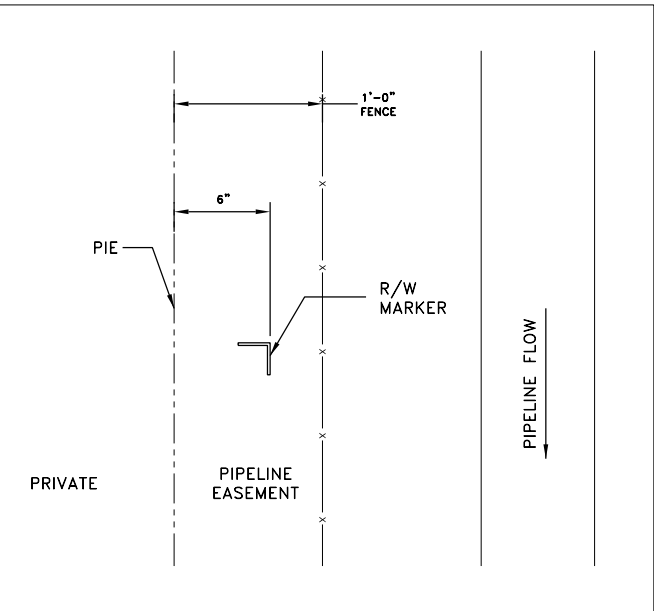

R/W MARKER PLACEMENT
SCALE: NONE

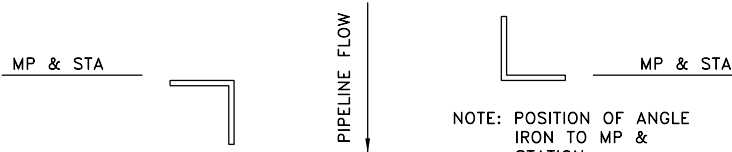


R/W MARKER LAYOUT
SCALE: NONE

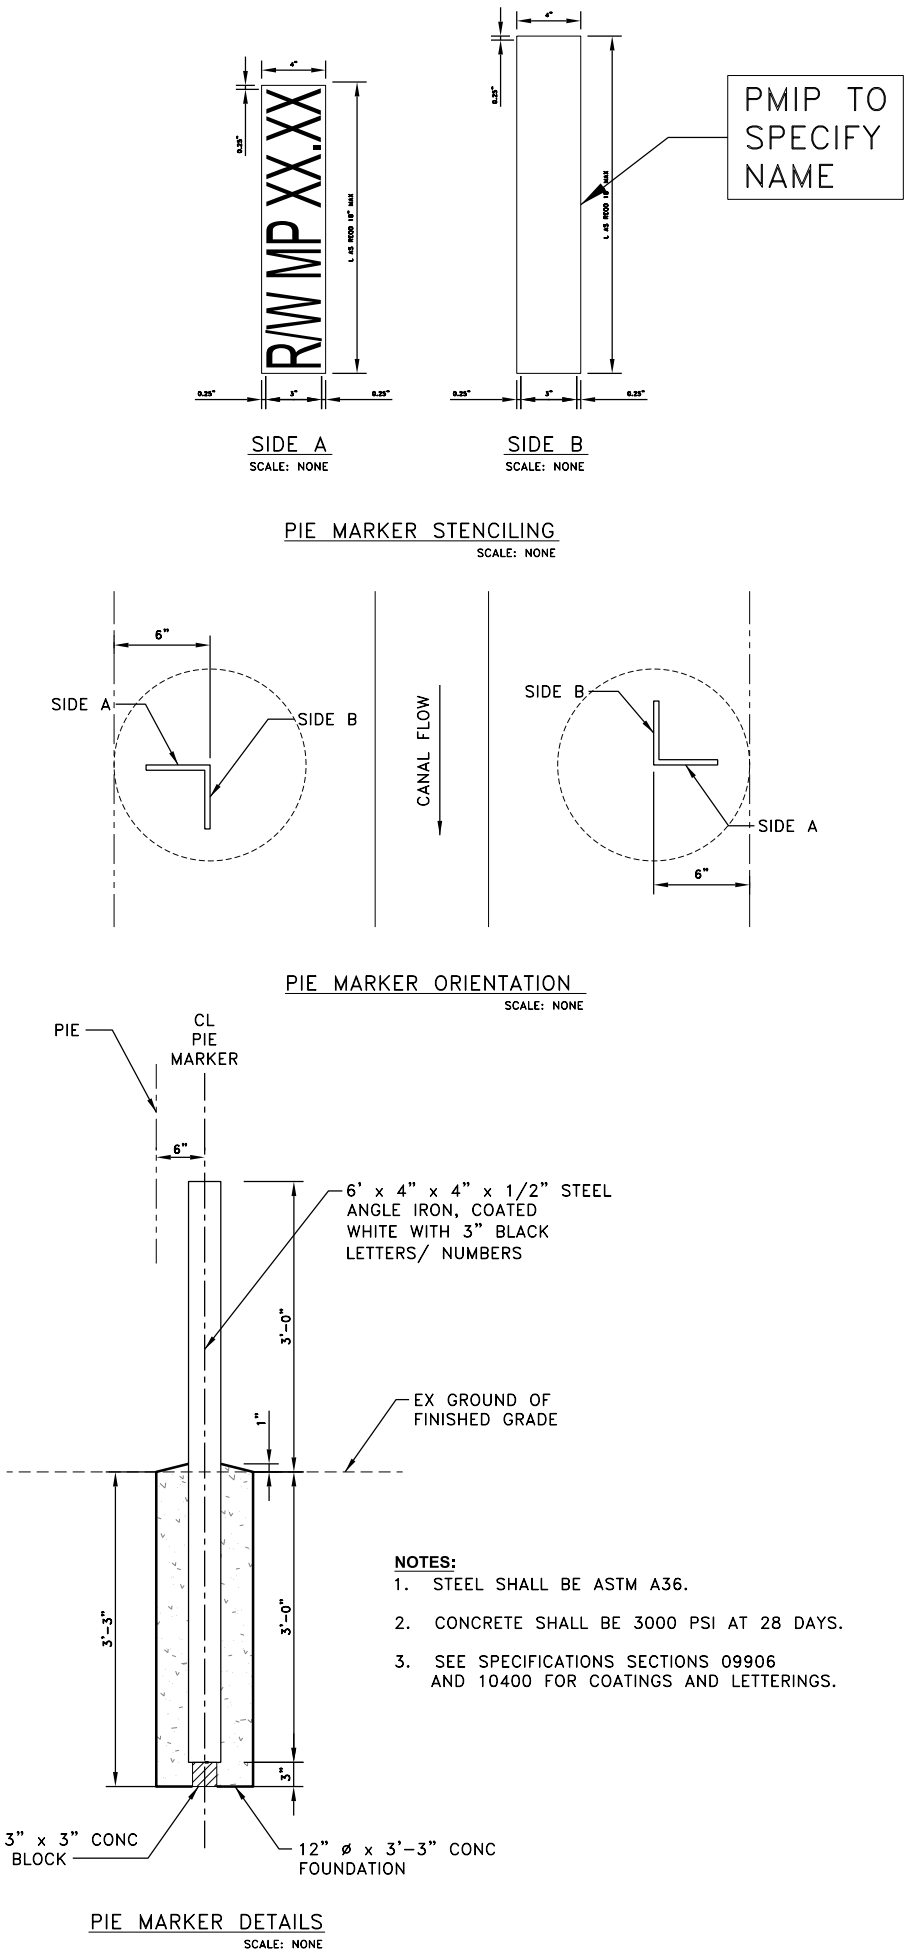

PIE MARKER DETAILS
SCALE: NONE

Job No.	647979	Designed	MFM	Drawn	JD	Checked	JZ	Reviewed	JZ	Reg. No.	25118	Plot Date	12-18-14	Rev	Date	Description	By
60% SUBMITTAL NOT FOR CONSTRUCTION																	
PREPARED BY: PARSONS 222 SOUTH MILL AVENUE SUITE #220 TEMPE, ARIZONA 85281 (602)952-9195 (602)952-9303 fax																	
																	
PIMA MARICOPA IRRIGATION PROJECT P.O. BOX C, ROUTE A STREET SACATON, AZ 85147 (520)562-6700 (520)562-6791 FAX																	
REACHES WS-1E AND WS-1F																	
REACHES WS1E & WS1F PIE MARKER SHEET 1 OF 2																	
DRAWING NAME M-7.0																	

PIE MARKER SCHEDULE		
TYPE	MARKER STATION	NO. MARKERS (LEFT AND RIGHT)
P.O.B.		
PC		
PT		
PC		
PT		
PC		
PT		
PC		
PT		
PC		
PT		
PC		
PT		
PC		
PT		
PC		
PT		
PI		
PI		
PC		
PT		
PC		
PT		
PC		
PT		
P.O.E.		
TOTAL		

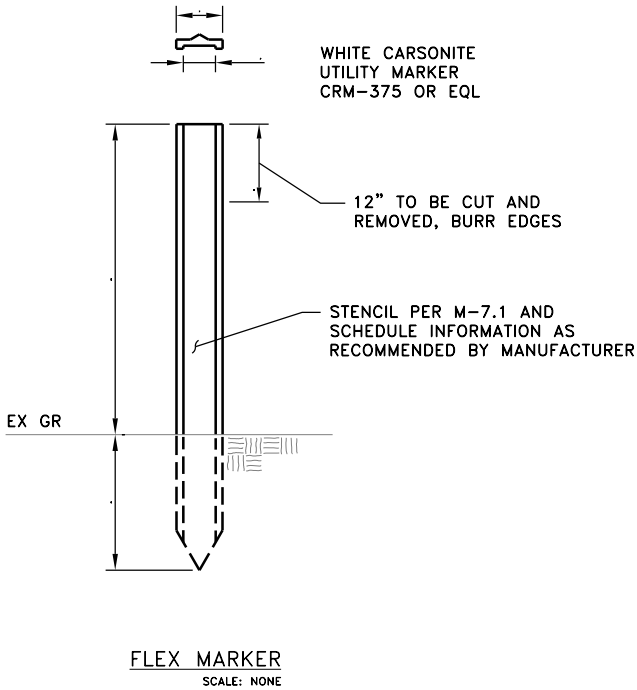

- NOTES:**
1. SEE THIS SHEET FOR ALL PIE FLEXMARKER DETAILS.
SEE SHEET M-7.1 FOR STANDARD PIE MARKER DETAILS.
 2. FLEX MARKER USED ONLY WHERE INDICATED WITH
IN SCHEDULE.

REACHES WS-1E AND WS-1F

REACHES WS1E & WS1F PIE MARKER
SHEET 2 OF 2

Job No. 647979

Designed MFM

Drawn JD

Checked JZ

Reviewed JZ

Approved JZ

Reg. No. 25118







Plot Date 12-18-14

60% SUBMITTAL
NOT FOR
CONSTRUCTION

PREPARED BY:
PARSONS
222 SOUTH MILL AVENUE
SUITE #220
TEMPE, ARIZONA 85281
(602)952-9195
(602)952-9303 fax


**PIMA
MARICOPA
IRRIGATION
PROJECT**
P.O. BOX C
ROUTE A STREET
SACATON, AZ 85147
(520)562-6700
(520)562-6791 FAX

DRAWING NAME
M-7.1

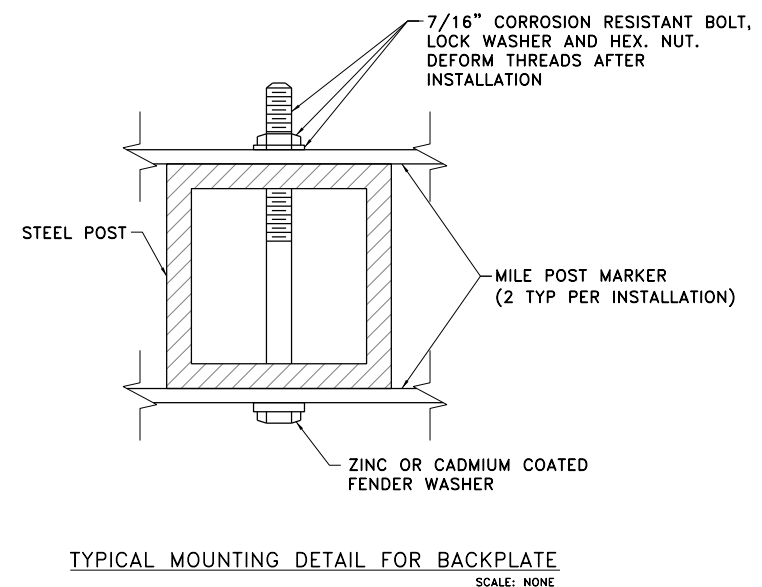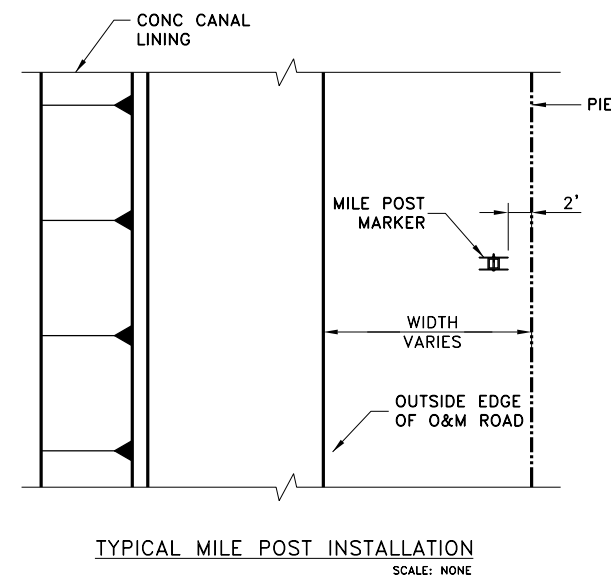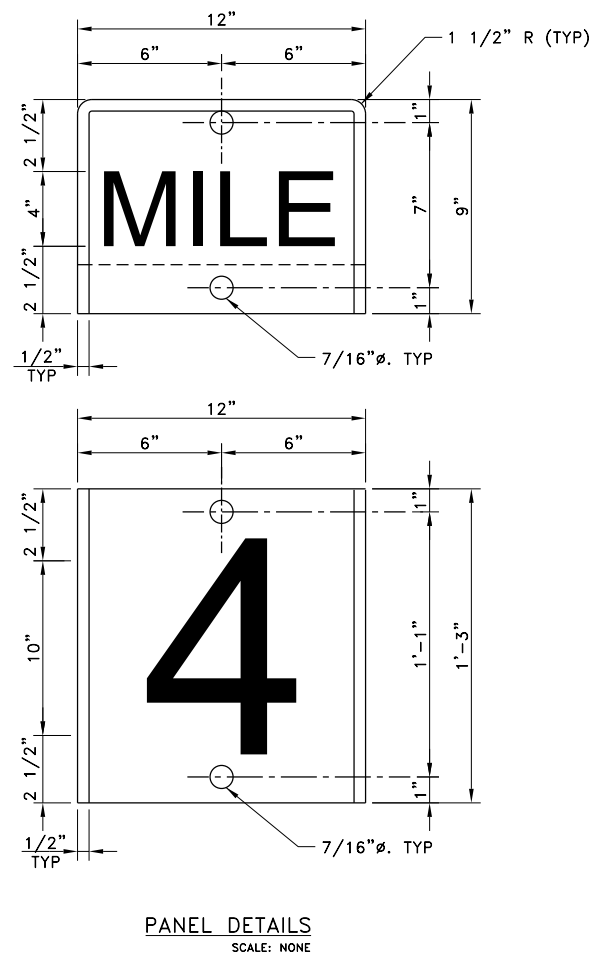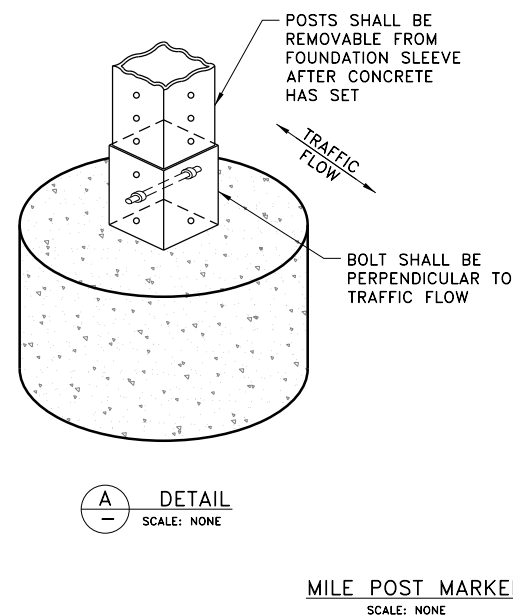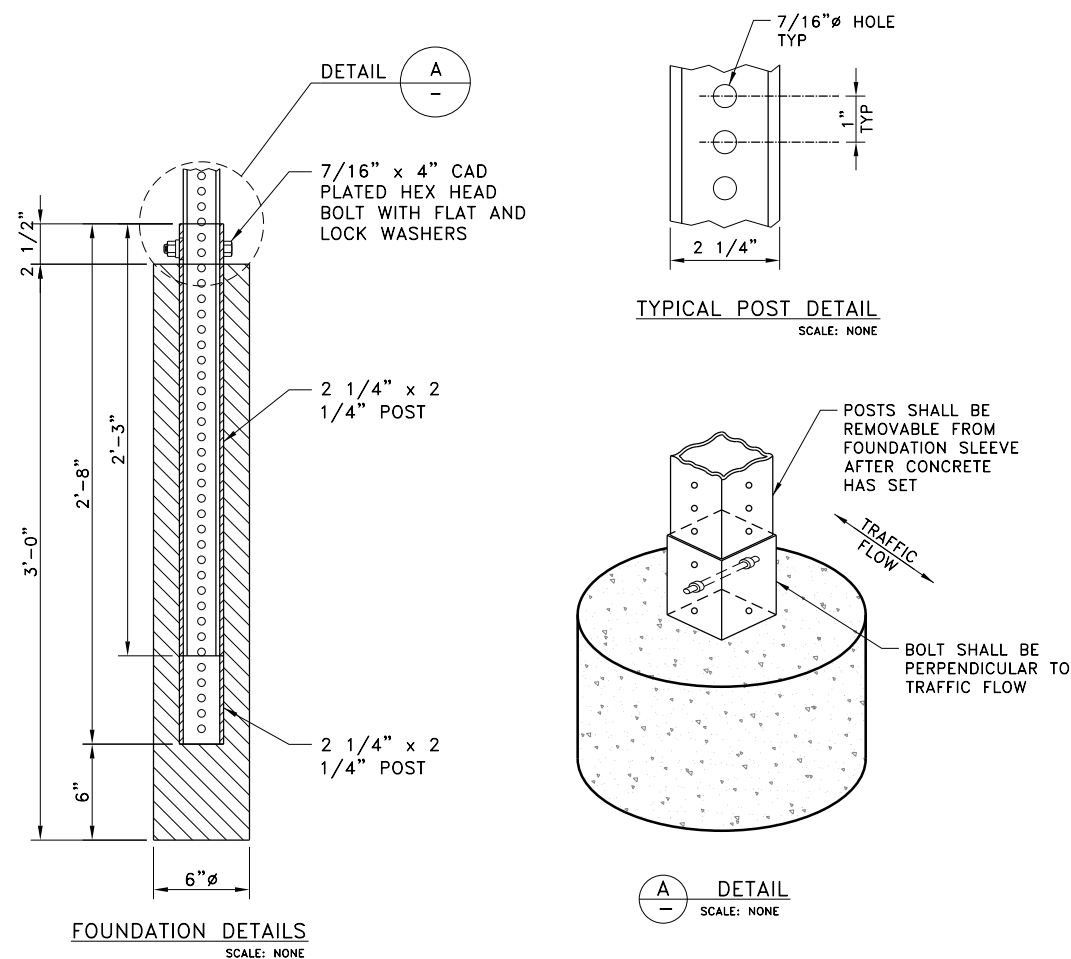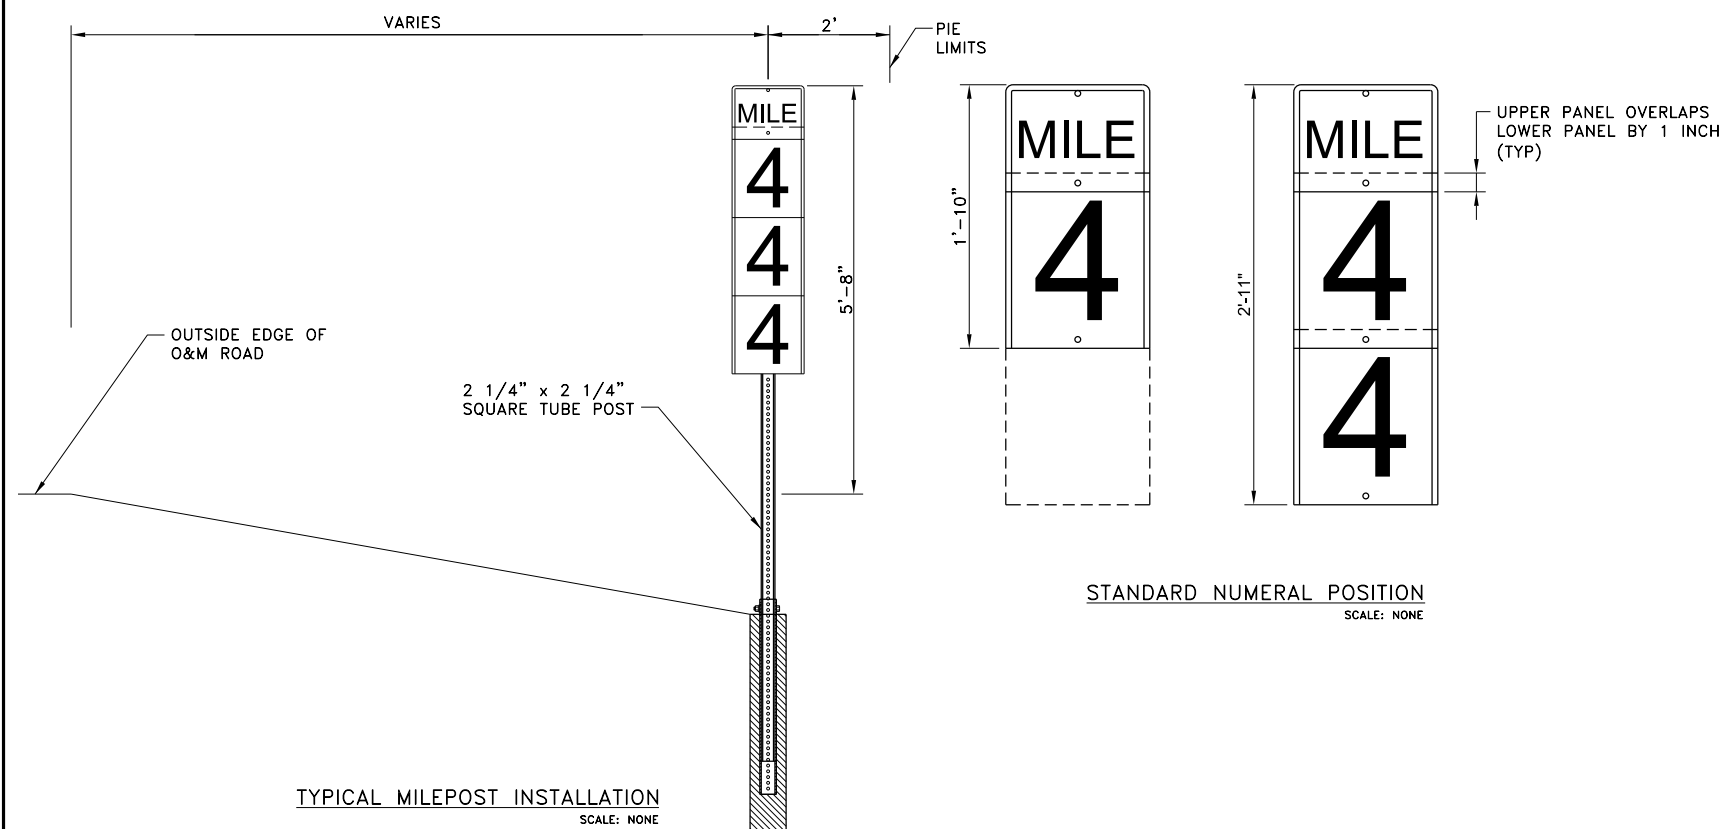

- NOTES:

1. ALL DIMENSIONS ARE IN INCHES EXCEPT AS NOTED.
2. MILEPOSTS SHALL BE PLACED ON THE RIGHT SIDE OF THE ROADWAY WITH PANELS FACING PERPENDICULAR TO CANAL CENTERLINE. IF THEY CAN NOT BE PLACED WITHIN 100 FOOT ACCURACY, THEY SHALL BE OMITTED.
3. THERE SHALL BE 2 MARKERS PER POST AT EACH INSTALLATION LOCATION WITH TEXT FACING OUTWARD.
4. ANY NEW MILEPOST SHALL BE INSTALLED IN THE SAME LONGITUDINAL LOCATION AS THE CORRESPONDING EXISTING MILEPOST.
5. MILEPOST PLATES SHALL BE FABRICATED FROM 0.062" THICK 3003-H14, 5052-H38, OR 6061-T6 ALUMINUM.
6. ALL SURFACES TO BE COVERED WITH REFLECTIVE SHEETING SHALL BE PREPARED IN ACCORDANCE WITH THE RECOMMENDATIONS OF THE SHEETING MANUFACTURER.
7. ALL LETTERS SHALL BE 4" C-SERIES. ALL NUMERALS SHALL BE 10" C-SERIES.
8. PANEL SURFACES NOT COVERED WITH SHEETING SHALL BE ETCHED TO REDUCE GLARE FROM REFLECTED SUNLIGHT.
9. POSTS SHALL BE PERFORATED SQUARE-TUBE FORMED FROM 0.105" ASTM A-366 COLD ROLLED CARBON STEEL. THE SQUARE TUBES SHALL BE WELDED DIRECTLY IN THE CORNERS BY HIGH-FREQUENCY RESISTANCE WELDING OR EQUAL. POSTS SHALL BE EXTERNALLY SCORED TO CONFORM TO STANDARD CORNER RADII OF 7/16" AND SHALL BE GALVANIZED TO CONFORM TO THE REQUIREMENTS OF ASTM A-525 COATING DESIGN G-90.
10. PANELS SHALL BE ATTACHED TO POSTS USING 7/16" SLOTTED HEAD BOLTS WITH HEX NUT, FLAT WASHER, LOCK WASHER, AND NYLON WASHER. FACE OF BOLT AND NYLON WASHER SHALL BE THE SAME COLOR AS THE MILEPOST PANEL. THE MAXIMUM OUTSIDE DIAMETER OF ALL WASHERS SHALL BE 7/8".
11. ALL HARDWARE SHALL CONFORM TO THE REQUIREMENTS OF ASTM A-307, CLASS A.
12. ALL CONCRETE SHALL BE UTILITY GRADE OR BETTER.

Job No.	647979
Designed	MFM
Drawn	JD
Checked	JZ
Reviewed	JZ
Approved	JZ
Reg. No.	25118
Plot Date	12-18-14

**60% SUBMITTAL
NOT FOR
CONSTRUCTION**

PREPARED BY:
PARSONS
222 SOUTH MILL AVENUE
SUITE #220
TEMPE, ARIZONA 85281
(602)852-9195
(602)952-9303 fax



**PIMA
MARICOPA
IRRIGATION
PROJECT**


REACHES WS-1E AND WS-1F

MILE POST MARKER

DRAWING NAME	M-8.0
--------------	-------



 1 THREE-RAIL HANDRAIL
- NOT TO SCALE



5 HANDRAIL POST CONNECTOR FOR BOLTED BASE PLATE
- NOT TO SCALE



ELEVATION

 
NOTES:

2 HINGE
- NOT TO SCALE



ELEVATION - TOE BOARD/
EXPANSION PLATE CONNECTION
(REQUIRED AT EACH CONCRETE
EXPANSION JOINT ALONG WALKWAY)

NOTES:

- 
- Diagram illustrating the Toe Board Inside Corner. The diagram shows a cross-section of the corner where two walls meet. A horizontal line represents the 'WALKWAY SIDE'. A vertical line represents the 'TOE BOARD'. An 'EXPANSION PLATE AT EVERY POST' is shown at the base of the toe board. The corner is reinforced with 'L2x2x1/8" ATTACH USING 4-1/4" SST RHMS, NYLON WASHERS & ELASTIC LOCK NUTS'.
- WALKWAY SIDE
- TOE BOARD
- EXPANSION PLATE AT EVERY POST
- L2x2x1/8" ATTACH USING 4-1/4" SST RHMS, NYLON WASHERS & ELASTIC LOCK NUTS
- PLAN - TOE BOARD
INSIDE CORNER
(OUTSIDE CORNER SIMILAR)

4 HANDRAIL TOE BOARD
NOT TO SCALE



(REQUIRED AT EACH
CONCRETE EXPANSION JOINT)



1. SPLICE HANDRAILS AS REQUIRED WITH SPLICE LOCKS. PROVIDE SPLICE LOCK SUITABLE FOR EXPANSION JOINT AT 50 FT. CENTERS MAXIMUM, AND AT EXPANSION JOINTS IN THE CONCRETE.
2. CONTRACTOR MUST HAVE OPTIONS FOR POST CONNECTIONS APPROVED BY ENGINEER FOR EACH SITE.

7 SAFETY CHAIN
NOT TO SCALE

[illegible]

**60% SUBMITTAL
NOT FOR
CONSTRUCTION**

PREPARED BY:
PARSONS
222 SOUTH MILL AVENUE
SUITE #220
TEMPE, ARIZONA 85281
(602)852-9195
(602)952-9303 fax






**PIMA
MARICOPA
ARRICOPAN
PROJECT**

P.O. BOX C
192-A SOUTH ROUTE A STREET
SACATON, AZ 85147
(520)562-6700
(520)562-6791 FAX


REACHES WS-1E AND WS-1F

HANDRAIL DETAILS


DRAWING NAME
M-9.0

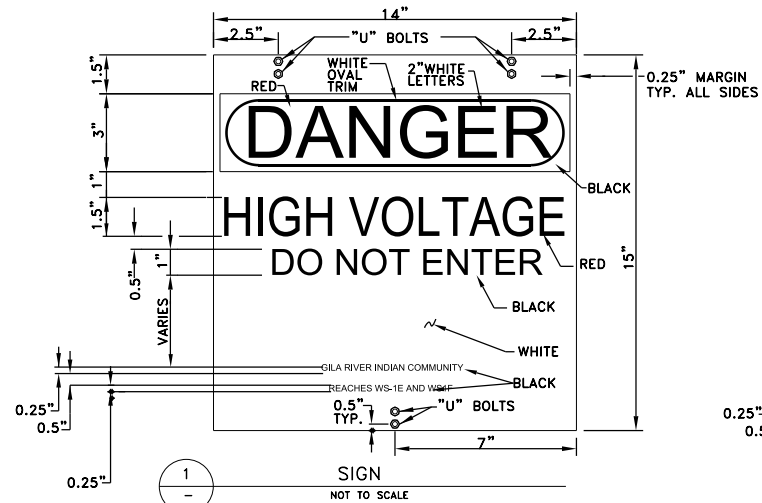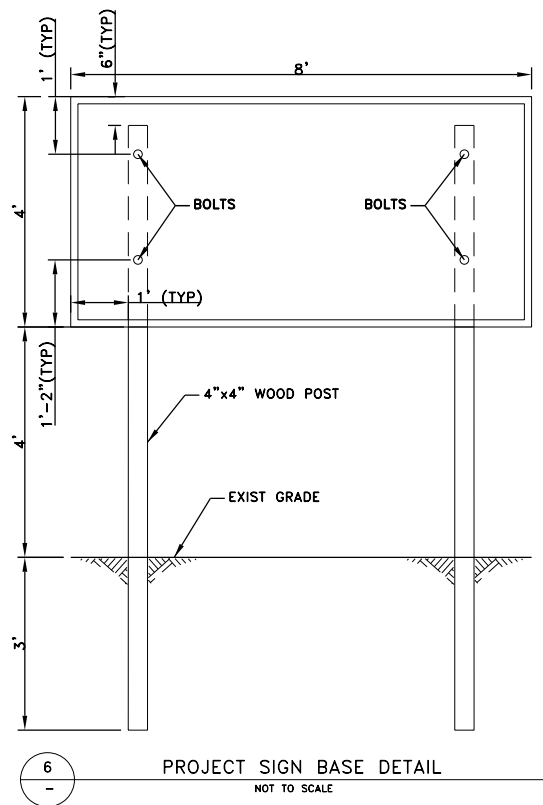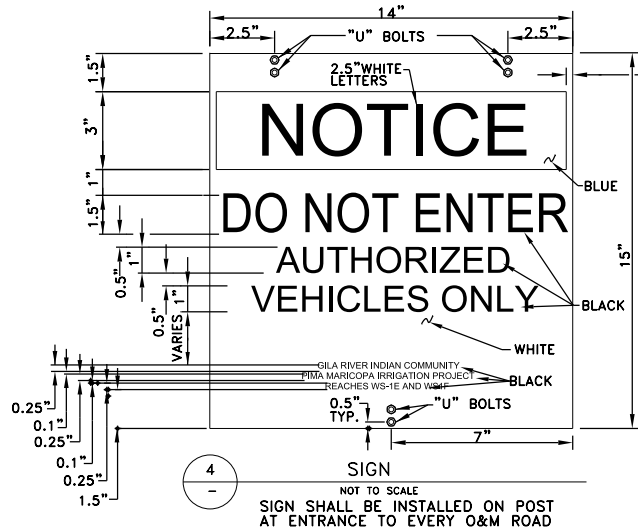


SIGN SHALL BE INSTALLED ON EACH FACE OF ELECTRICAL BUILDING AND ON EACH CHAIN LINK FENCE GATE AT EACH ELECTRICAL FENCE ENCLOSURE. (SEE NOTE 1)

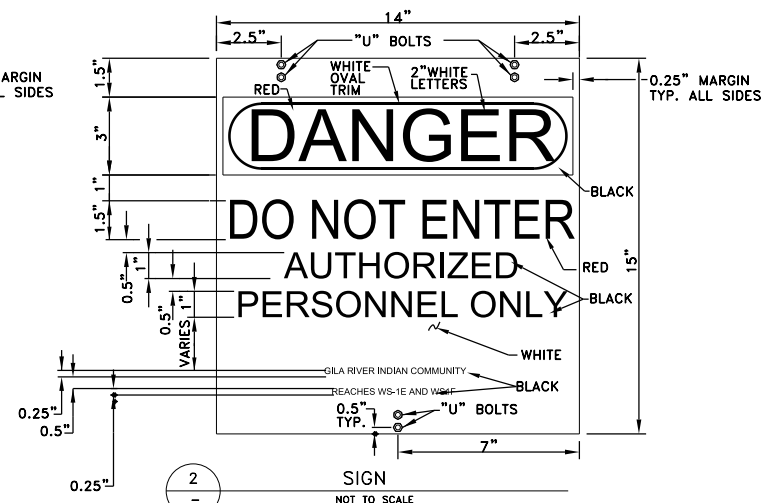

SIGN SHALL BE INSTALLED ON EACH CHAIN LINK FENCE GATE. (SEE NOTE 1)

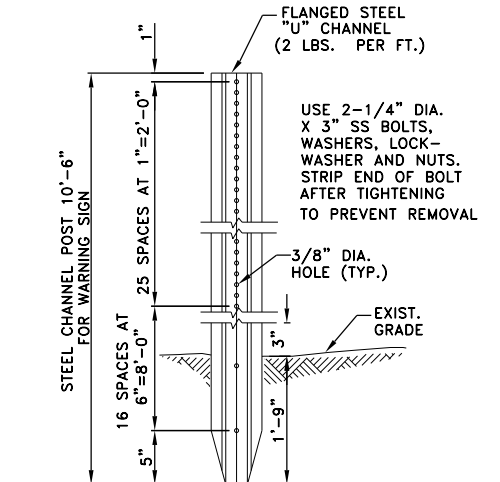

POST SHALL BE INSTALLED AT ALL O&M ROAD ENTRANCES. SIGNS IN DETAILS 4 AND 5 SHALL BE ATTACHED TO POST.

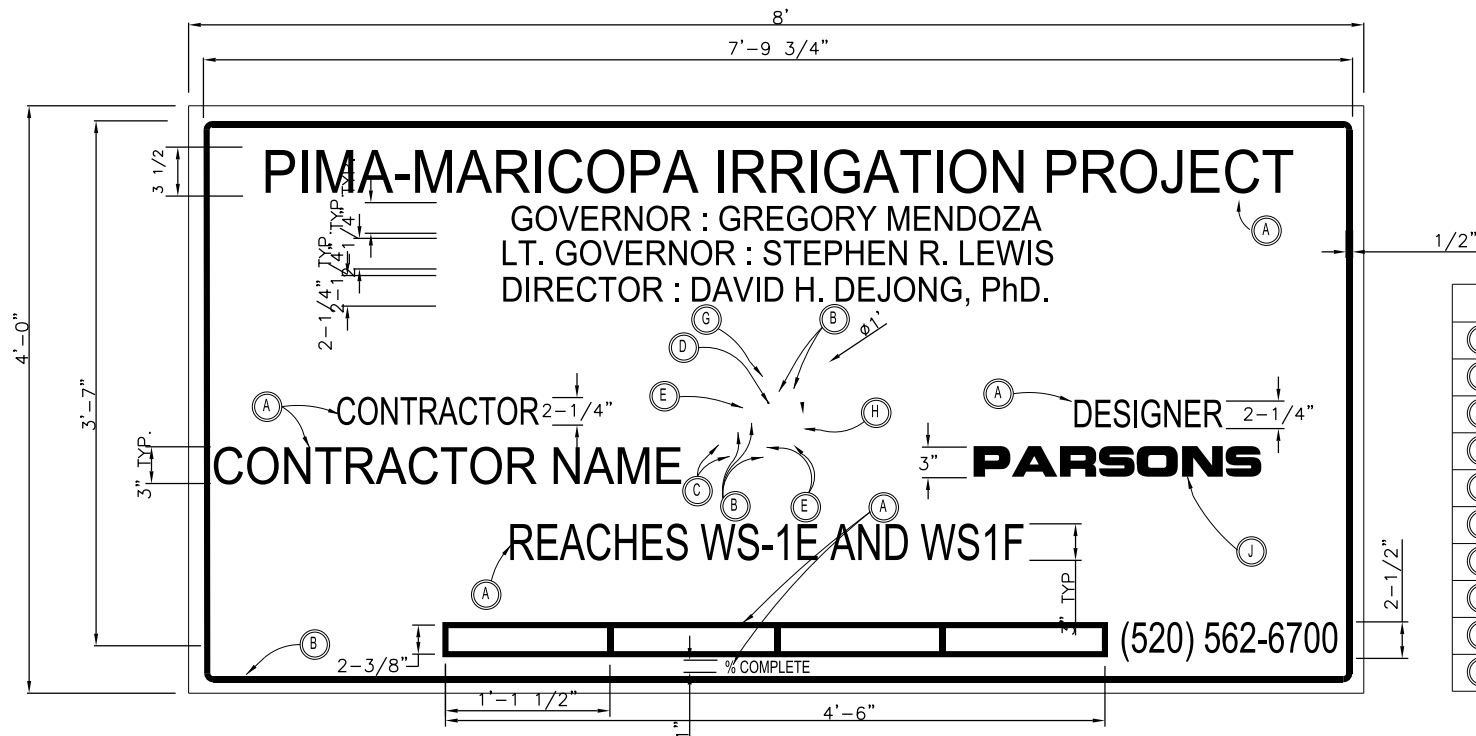

SIGNS SHALL BE INSTALLED PER INSTRUCTION OF ENGINEER. (SEE NOTE 3)

1. SIGNS SHALL BE ATTACHED TO FENCE GATE WITH 3- 1/4" PIPE "U" BOLTS, FLAT WASHERS, LOCK WASHERS, AND NUTS. BOLTS, NUTS, AND WASHERS SHALL BE ZINC COATED AND LOCATED AS SHOWN ON DETAIL. TOP OF SIGN SHALL BE 5' FROM GROUND ELEVATION. BOLTS SHALL BE SCORED AFTER NUT INSTALLATION TO PREVENT REMOVAL. MAXIMUM LENGTH OF PROTRUDING BOLT AFTER NUT INSTALLATION SHALL BE 1/4".

2. BOLT ATTACHMENTS SHALL NOT COVER SIGN LETTERING.

3. LABELING FOR REACH DESIGNATION ON PROJECT IDENTIFICATION SIGNS SHALL BE PER ENGINEER INSTRUCTIONS. CONTRACTOR SHALL PROVIDE A TOTAL OF 2 PROJECT SIGNS.

COLOR TABLE	
(A)	DARK BROWN
(B)	LIGHT BROWN
(C)	YELLOW
(D)	GOLD
(E)	KELLY GREEN
(F)	DARK GREEN
(G)	SKY BLUE
(H)	MINT GREEN
(I)	MAROON
(J)	PANTONE 108

TO BE DEVELOPED
FOR 90% SUBMITTAL

DRAWING NAME
TC-1.1

REACHES WS-1E AND WS-1F

TRAFFIC CONTROL SCHEMATIC

PIMA
MARICOPA
IRRIGATION
PROJECT
P.O. BOX C
192-A SOUTH ROUTE A STREET
SACATON, AZ 85147
(520)562-6700
(520)562-6791 FAX



PREPARED BY:
PARSONS
222 SOUTH MILL AVENUE
SUITE 100
TEMPE, ARIZONA 85281
(602)952-9195
(602)952-9303 fax

60% SUBMITTAL
NOT FOR
CONSTRUCTION

Job No. 647979
Designed MFM
Drawn JD
Checked JZ
Reviewed JZ
Approved JZ
Reg. No. 25118
Plot Date 12-18-14

Description

Date

Rev

By

TO BE DEVELOPED
FOR 90% SUBMITTAL

DRAWING NAME
TC-1.2

REACHES WS-1E AND WS-1F

TRAFFIC CONTROL QUANTITIES

PIMA
MARICOPA
IRRIGATION
PROJECT
P.O. BOX C
192-A SOUTH ROUTE A STREET
SACATON, AZ 85147
(520)562-6700
(520)562-6791 FAX



PREPARED BY:
PARSONS
222 SOUTH MILL AVENUE
SUITE 100
TEMPE, ARIZONA 85281
(602)952-9195
(602)952-9303 fax

60% SUBMITTAL
NOT FOR
CONSTRUCTION

Job No. 647979
Designed MFM
Drawn JD
Checked JZ
Reviewed JZ
Approved JZ
Reg. No. 25118
Plot Date 12-18-14

Description

Date

Rev

By

TO BE DEVELOPED
FOR 90% SUBMITTAL

DRAWING NAME
TC-1.3

REACHES WS-1E AND WS-1F

TRAFFIC CONTROL DETAILS

PIMA
MARICOPA
IRRIGATION
PROJECT
P.O. BOX C
192-A SOUTH ROUTE A STREET
SACATON, AZ 85147
(520)562-6700
(520)562-6791 FAX



PREPARED BY:
PARSONS
222 SOUTH MILL AVENUE
SUITE 100
TEMPE, ARIZONA 85281
(602)952-9195
(602)952-9303 fax

**60% SUBMITTAL
NOT FOR
CONSTRUCTION**

Job No. 647979
Designed MM
Drawn JD
Checked JZ
Reviewed JZ
Approved JZ
Reg. No. 25118
Plot Date 12-18-14

Description

Date

Rev

By

TO BE DEVELOPED
FOR 90% SUBMITTAL

DRAWING NAME
TC-1.4

REACHES WS-1E AND WS-1F

TRAFFIC CONTROL

PIMA
MARICOPA
IRRIGATION
PROJECT
P.O. BOX C
192-A SOUTH ROUTE A STREET
SACATON, AZ 85147
(520)562-6700
(520)562-6791 FAX



PREPARED BY:
PARSONS
222 SOUTH MILL AVENUE
SUITE 100
TEMPE, ARIZONA 85281
(602)952-9195
(602)952-9303 fax

60% SUBMITTAL
NOT FOR
CONSTRUCTION

Job No. 647979
Designed MFM
Drawn JD
Checked JZ
Reviewed JZ
Approved JZ
Reg. No. 25118
Plot Date 12-18-14

Description

Date

Rev

By

TO BE DEVELOPED
FOR 90% SUBMITTAL

DRAWING NAME
TC-1.5

REACHES WS-1E AND WS-1F

TRAFFIC CONTROL

PIMA
MARICOPA
IRRIGATION
PROJECT
P.O. BOX C
192-A SOUTH ROUTE A STREET
SACATON, AZ 85147
(520)562-6700
(520)562-6791 FAX



PREPARED BY:
PARSONS
222 SOUTH MILL AVENUE
SUITE 100
TEMPE, ARIZONA 85281
(602)952-9195
(602)952-9303 fax

**60% SUBMITTAL
NOT FOR
CONSTRUCTION**

Job No. 647979
Designed MM
Drawn JD
Checked JZ
Reviewed JZ
Approved JZ
Reg. No. 25118
Plot Date 12-18-14

Description

Date

Rev

By

TO BE DEVELOPED
FOR 90% SUBMITTAL

DRAWING NAME
TC-1.6

REACHES WS-1E AND WS-1F

TRAFFIC CONTROL

PIMA
MARICOPA
IRRIGATION
PROJECT
P.O. BOX C
192-A SOUTH ROUTE A STREET
SACATON, AZ 85147
(520)562-6700
(520)562-6791 FAX



PREPARED BY:
PARSONS
222 SOUTH MILL AVENUE
SUITE 100
TEMPE, ARIZONA 85281
(602)952-9195
(602)952-9303 FAX

**60% SUBMITTAL
NOT FOR
CONSTRUCTION**

Job No. 647979
Designed MFM
Drawn JD
Checked JZ
Reviewed JZ
Approved JZ
Reg. No. 25118
Plot Date 12-18-14


Description

Date


Rev

By


THIS SUMMARY APPLIES ONLY AT THIS LOCATION AND AT THE TIME OF LOGGING. CONDITIONS MAY DIFFER AT OTHER LOCATIONS AND MAY CHANGE AT THIS LOCATION WITH TIME. DATA PRESENTED IS A SIMPLIFICATION.

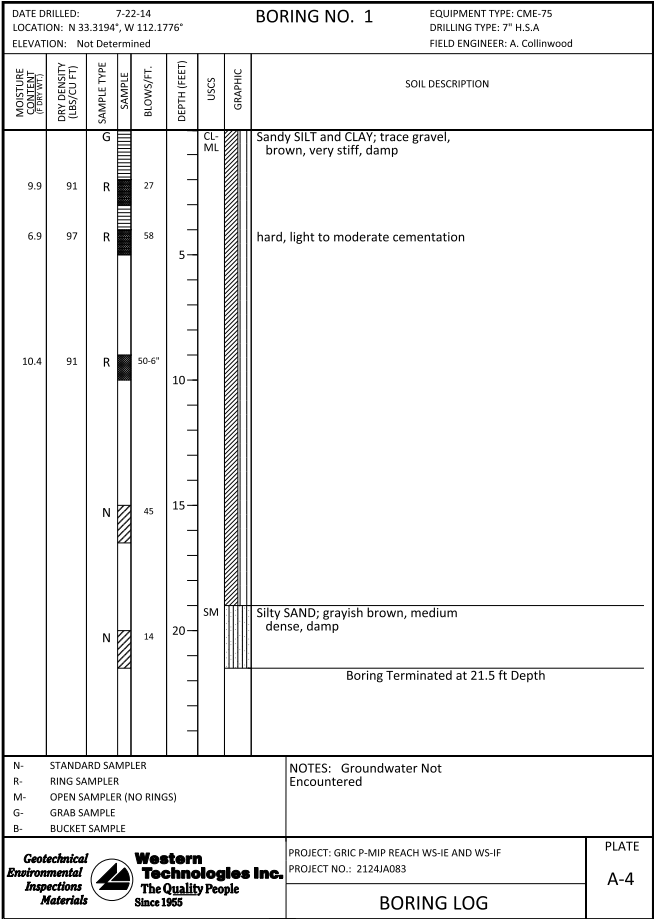


THIS SUMMARY APPLIES ONLY AT THIS LOCATION AND AT THE TIME OF LOGGING. CONDITIONS MAY DIFFER AT OTHER LOCATIONS AND MAY CHANGE AT THIS LOCATION WITH TIME. DATA PRESENTED IS A SIMPLIFICATION.

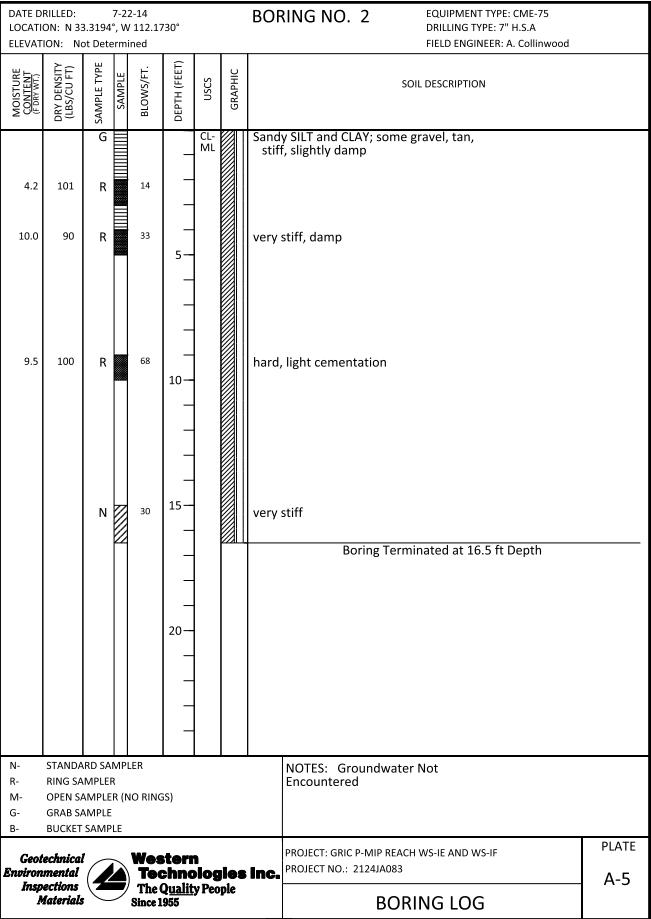


THIS SUMMARY APPLIES ONLY AT THIS LOCATION AND AT THE TIME OF LOGGING. CONDITIONS MAY DIFFER AT OTHER LOCATIONS AND MAY CHANGE AT THIS LOCATION WITH TIME. DATA PRESENTED IS A SIMPLIFICATION.

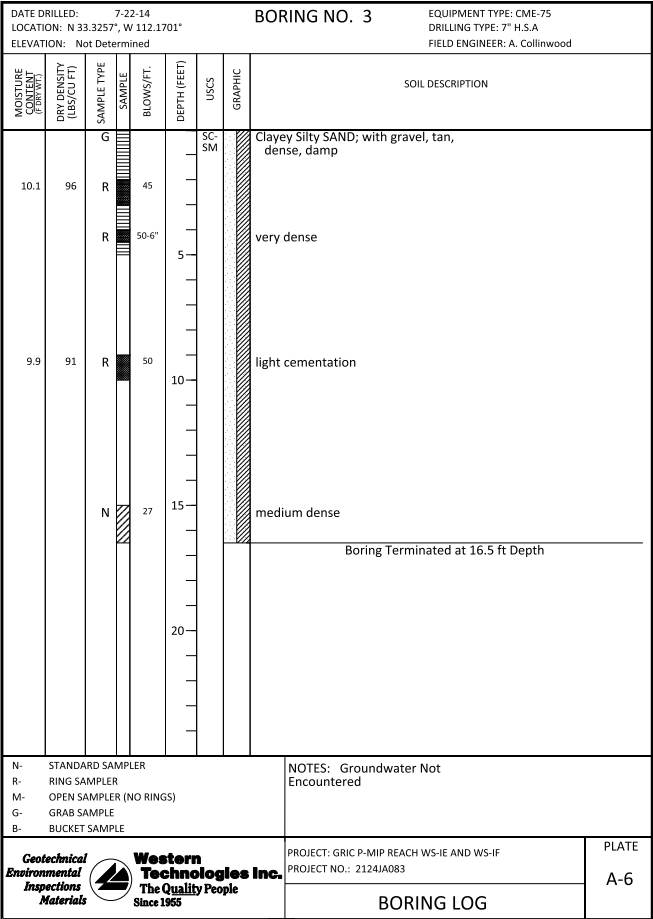


THIS SUMMARY APPLIES ONLY AT THIS LOCATION AND AT THE TIME OF LOGGING. CONDITIONS MAY DIFFER AT OTHER LOCATIONS AND MAY CHANGE AT THIS LOCATION WITH TIME. DATA PRESENTED IS A SIMPLIFICATION.

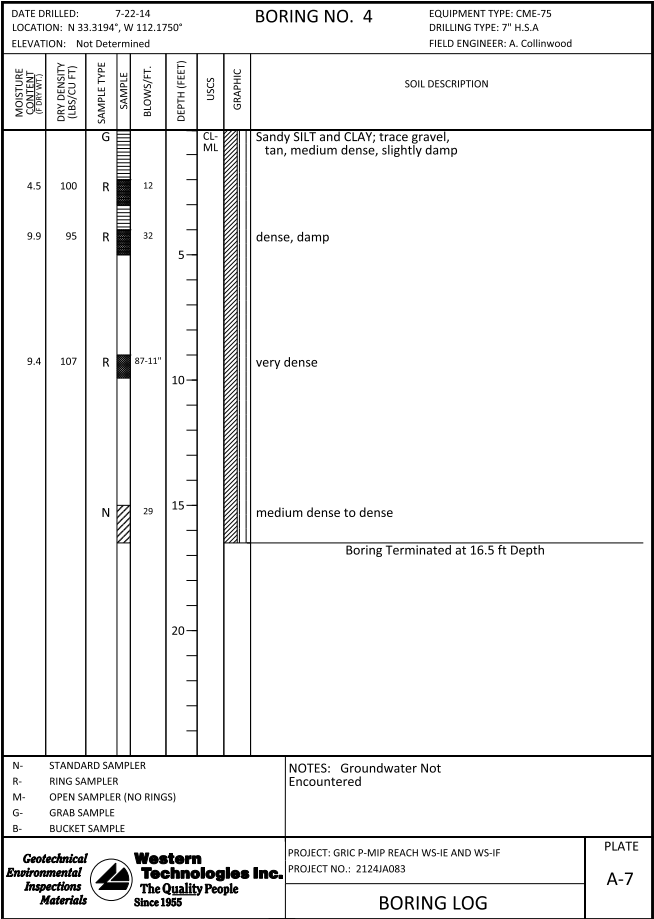


THIS SUMMARY APPLIES ONLY AT THIS LOCATION AND AT THE TIME OF LOGGING. CONDITIONS MAY DIFFER AT OTHER LOCATIONS AND MAY CHANGE AT THIS LOCATION WITH TIME. DATA PRESENTED IS A SIMPLIFICATION.

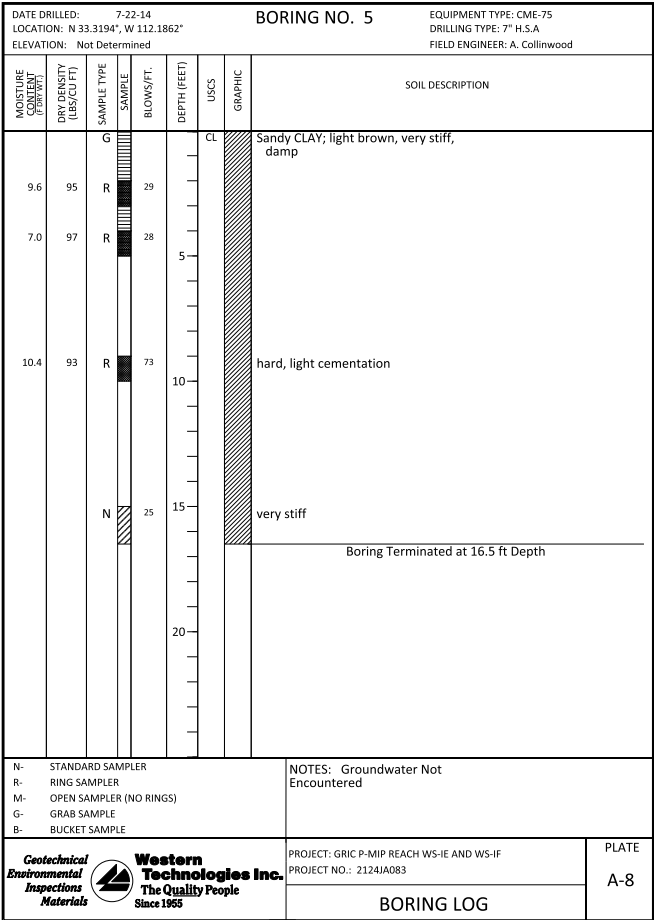


THIS SUMMARY APPLIES ONLY AT THIS LOCATION AND AT THE TIME OF LOGGING. CONDITIONS MAY DIFFER AT OTHER LOCATIONS AND MAY CHANGE AT THIS LOCATION WITH TIME. DATA PRESENTED IS A SIMPLIFICATION.

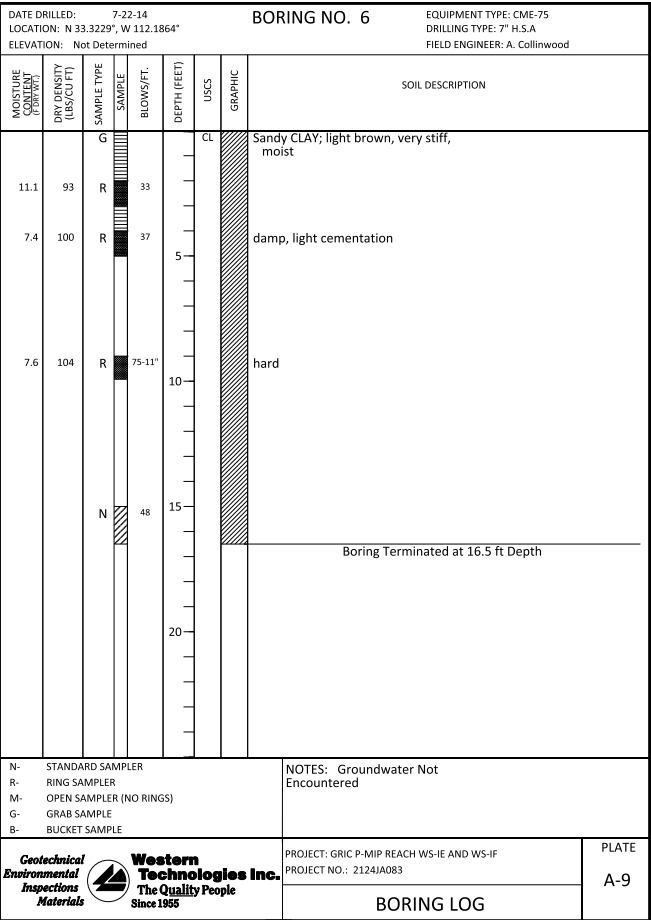

THIS SUMMARY APPLIES ONLY AT THIS LOCATION AND AT THE TIME OF LOGGING. CONDITIONS MAY DIFFER AT OTHER LOCATIONS AND MAY CHANGE AT THIS LOCATION WITH TIME. DATA PRESENTED IS A SIMPLIFICATION.

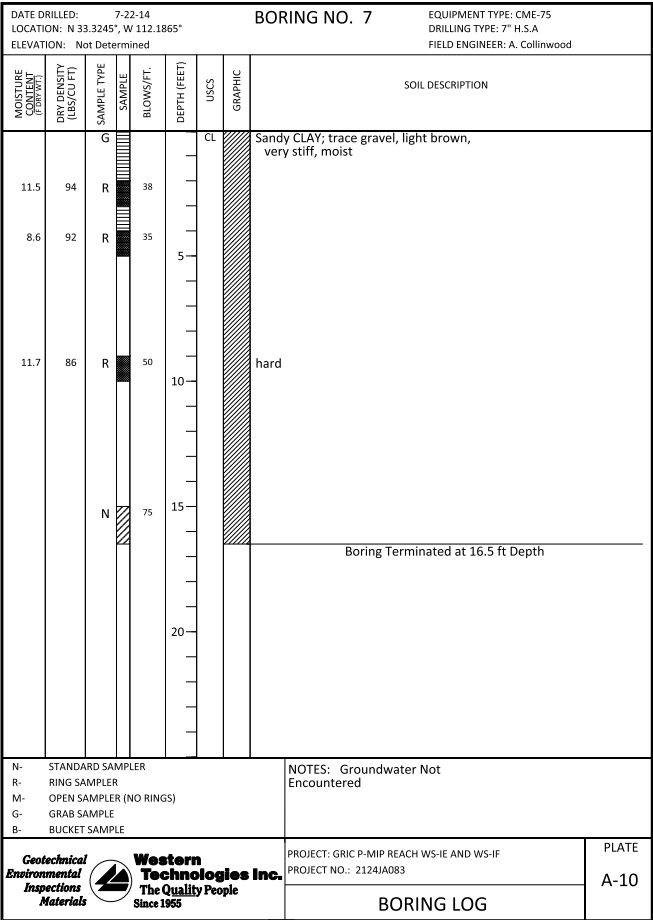

THIS SUMMARY APPLIES ONLY AT THIS LOCATION AND AT THE TIME OF LOGGING. CONDITIONS MAY DIFFER AT OTHER LOCATIONS AND MAY CHANGE AT THIS LOCATION WITH TIME. DATA PRESENTED IS A SIMPLIFICATION.

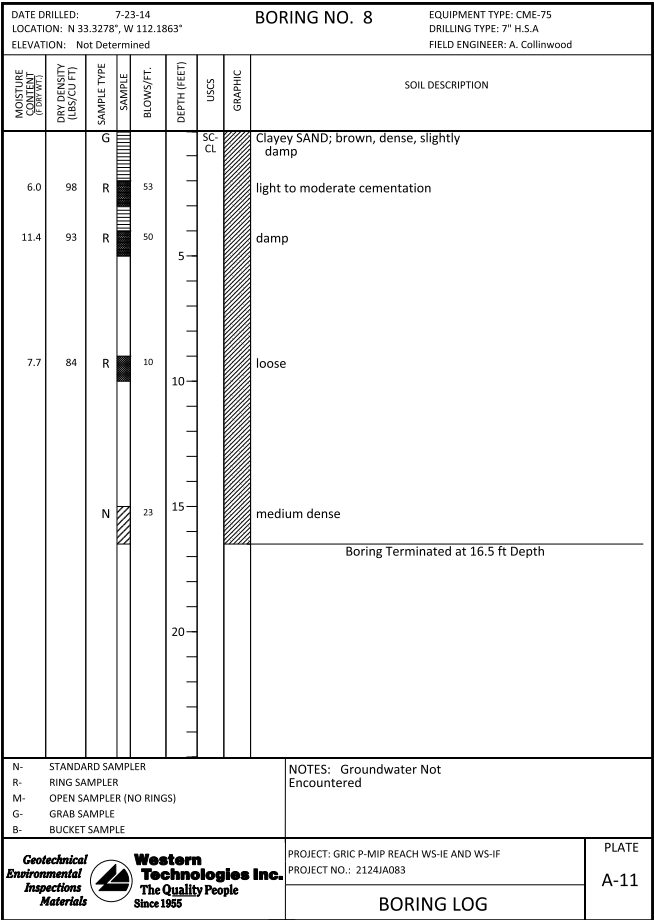

Job No. 647979		Designed		Drawn		Checked		Reviewed		Approved		Reg. No. 25118		Plot Date 12-18-14		Description		By			
60% SUBMITTAL NOT FOR CONSTRUCTION																					
PREPARED BY:																		WESTERN TECHNOLOGIES INC. 3137 Eng. Building, Suite 100 Phoenix, AZ 85018 (602) 437-3377 (602) 470-1341 FAX			
PIMA MARICOPA IRRIIGATION PROJECT 100 BOX 10TH ROUTE A STREET SACATON, AZ 85147 (520)562-6700 (520)562-6791 FAX																		GILA RIVER INDIAN COMMUNITY 1935			
REACHES WS-IE AND WS-IF																					
SOIL BORING AND LOG																					
DRAWING NAME SB-1.0																					